
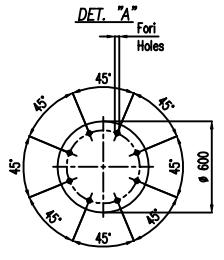
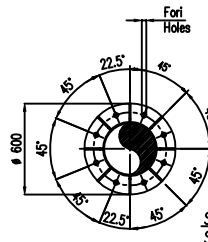



Monitore tipo A4-EL
con bocchello elettrico tipo FOG
Electric monitor A4-EL L.A. type
with FULL-FOG jet adj. nozzle

IMPORTANTE :
CACCIALANZA & C. S.p.A. si riserva il diritto di modificare senza preavviso le informazioni
contenute su questo scheda con il proposito di apportare miglioramenti alla produzione
IMPORTANT :
CACCIALANZA & C. S.p.A. reserves the right to change or modify without previous notice any data
or specification due to changes or modification in order to improve the products presented

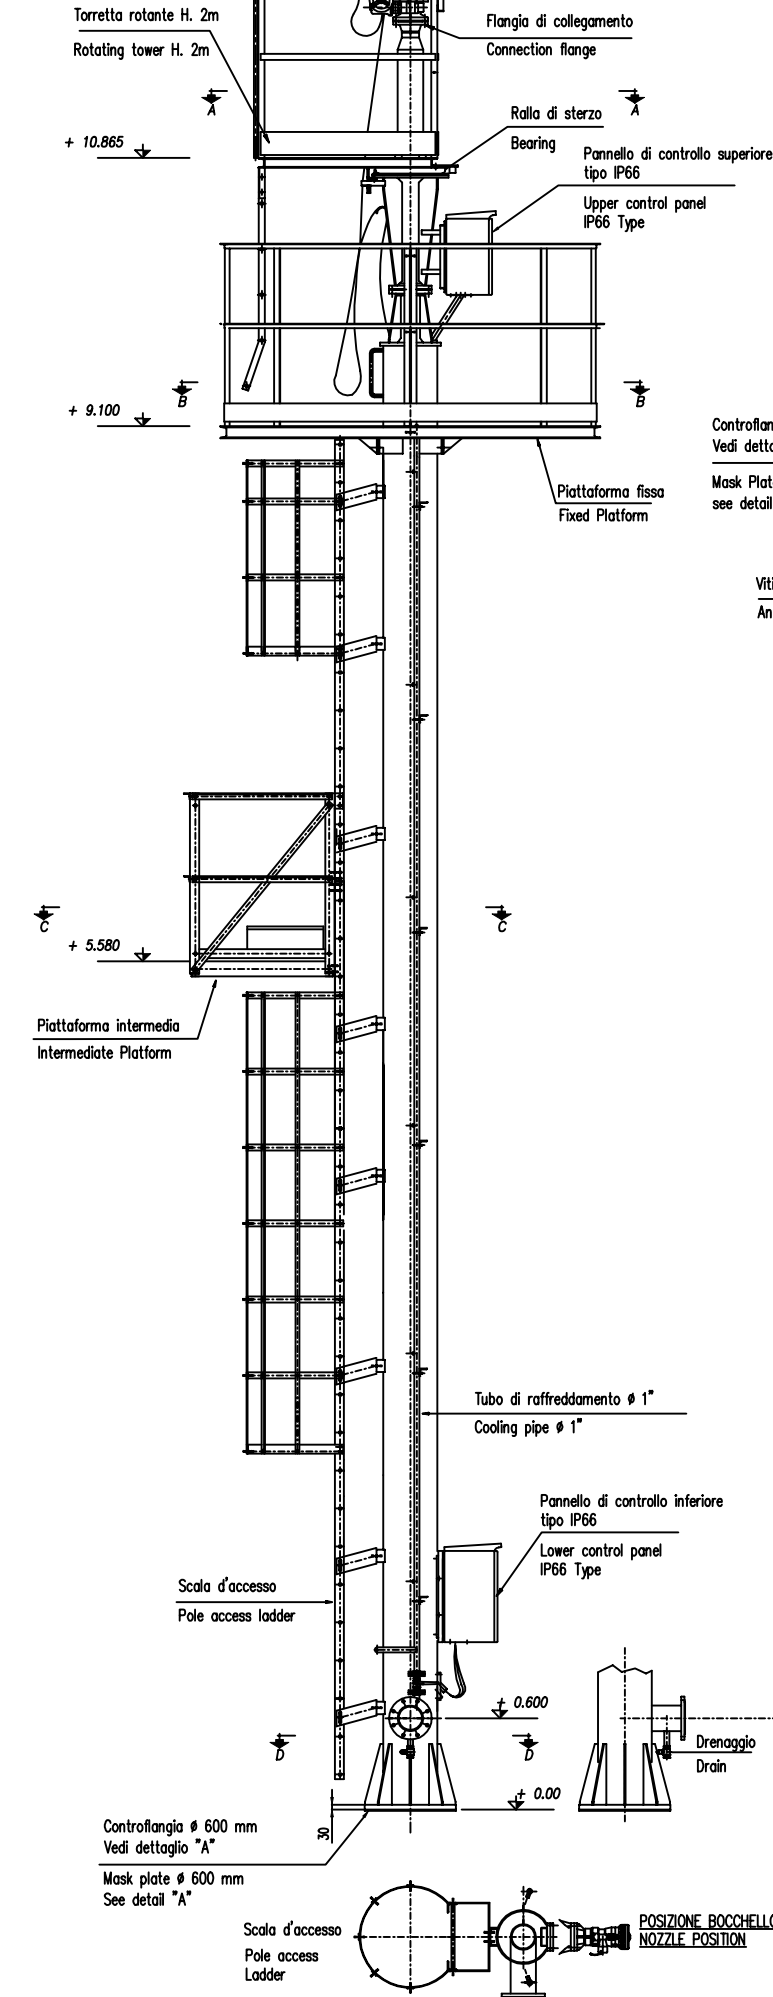


CONTROFLANGIA
MASK PLATE
Ø 600 thk. 10

DET. 'B'

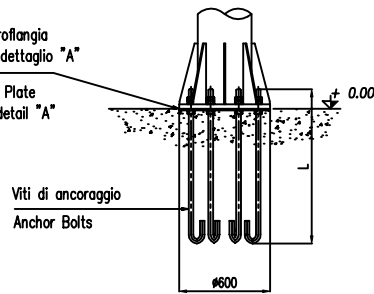


SEZIONE 'A-A'
SECTION 'A-A'

TORRETTA ROTANTE (TIPICA)
ROTARY TURRET (TYPICAL)

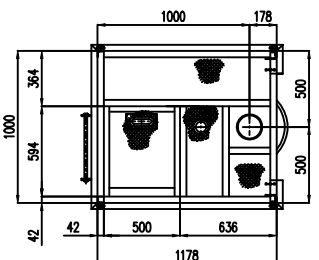


SEZIONE 'B-B'
SECTION 'B-B'

PIATTAFORMA FISSA (TIPICA)
FIXED PLATFORM (TYPICAL)

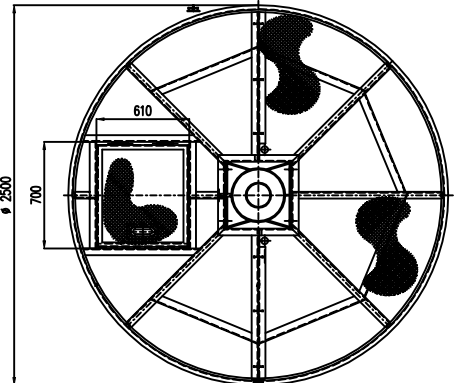

SEZIONE 'C-C'
SECTION 'C-C'

PIATTAFORMA INTERMEDIA (TIPICA)
INTERMEDIATE PLATFORM (TYPICAL)

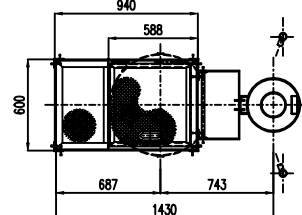

Ø 6" ANSI 150 #
DN 150 UNI PN 16

0	11.05.2000	Emesso - Issued		MP	MB
Rev.	Date	Description		Drawn	Checked
CACCIALANZA & C. s.p.a. ANTINCENDIO SICUREZZA ANTINCENDIAMENTO SEGRATE (MILANO) - ITALY			Client / Project		
Drawn	Date	Name	Title		
Checked	11.05.00	M. PELIZZARI	PALO H.10m CON MONITORE TIPO A4EL E BOCCHE. ELETTRICO ASSEMBLIE GENERALE		
Approved	11.05.00	M. BARBERI	POLE H.10m WITH MONITOR A4EL TYPE & FULL FOG ADJ. NOZZLE GENERAL ASSEMBLY		
Code	Sys.	Size	Scale	Dwg nr.	Rev.
		A2	1:25	06977112	0
					Sheet 1 of 1

PALO CON TORRETTA ROTANTE H. 10m + 2m
POLE WITH ROTATING TOWER H. 10m + 2m

THIS DRAWING IS THE PROPERTY OF CACCIALANZA & C. S.p.A. AND IS NOT TO BE REPRODUCED OR USED TO FURNISH ANY INFORMATION FOR MAKING OF DRAWINGS OR APPARATUS EXCEPT WHERE PROVIDED FOR BY AGREEMENT WITH SAID COMPANY