







Monitore tipo A6 EL  
con bocchello elettrico

Electric monitor A6-EL type  
with FULL-FOG adjustable nozzle

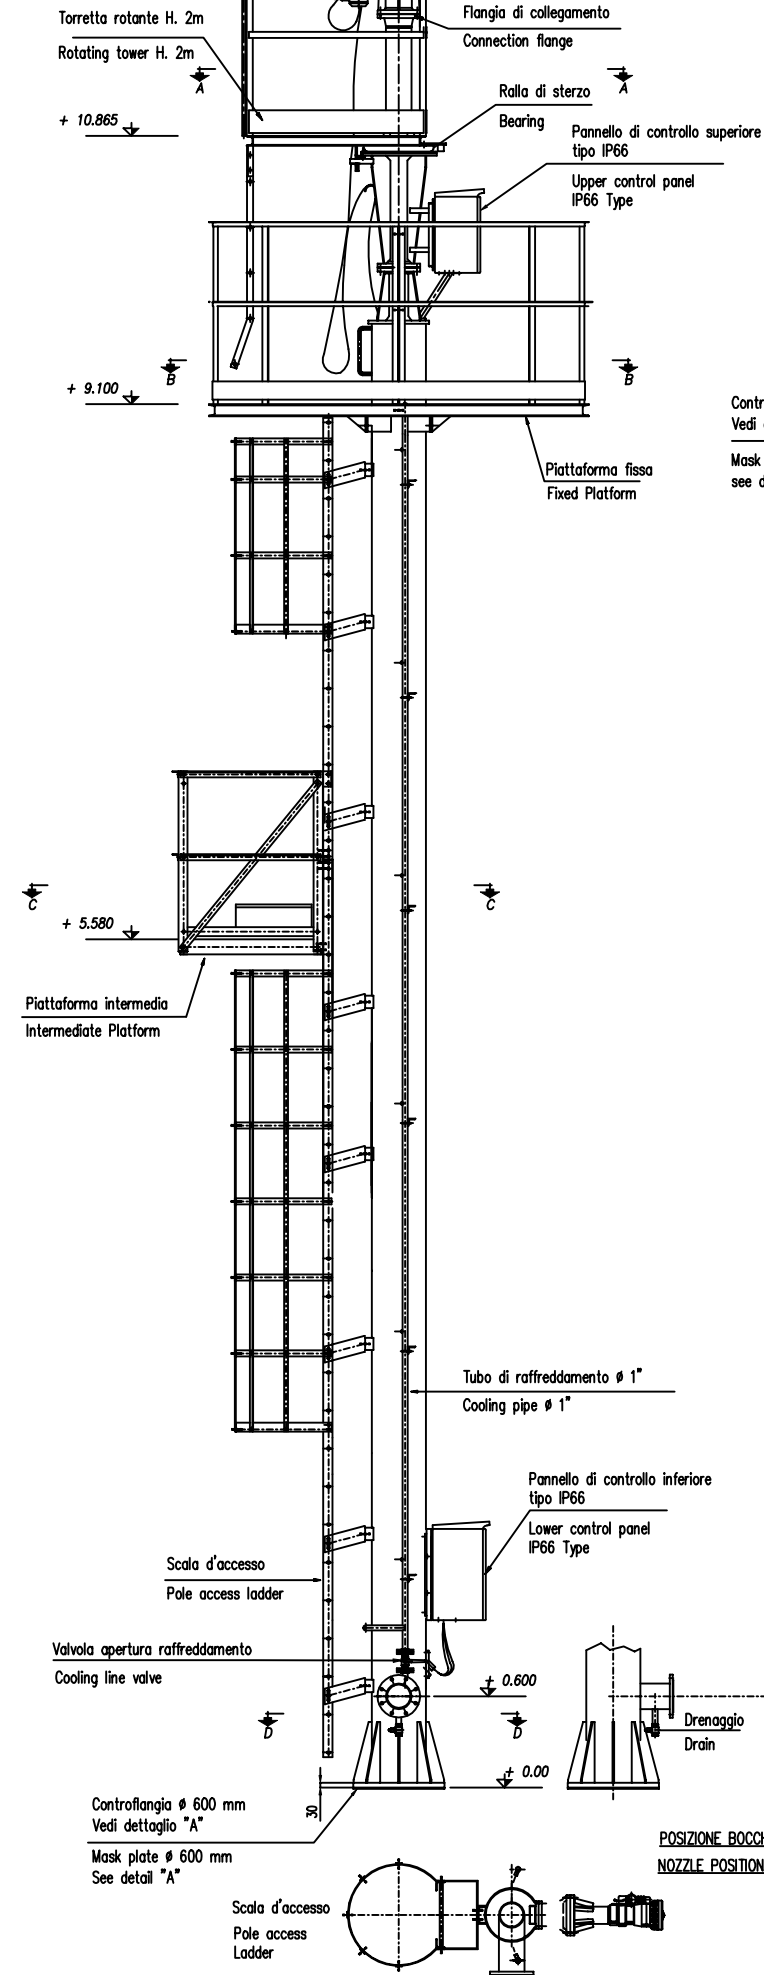

IMPORTANTE :  
CACCIALANZA & C. S.p.A. si riserva il diritto di modificare senza preavviso le informazioni  
contenute su questo scheda con il proposito di apportare miglioramenti alla produzione

 IMPORTANT :  
CACCIALANZA & C. S.p.A. reserves the right to change or modify without previous notice any data  
or specification due to changes or modification in order to improve the products presented

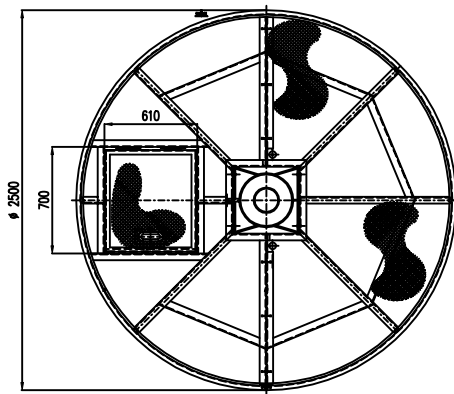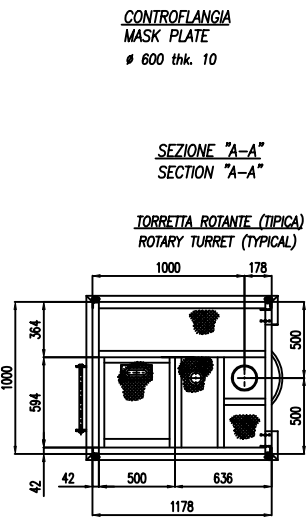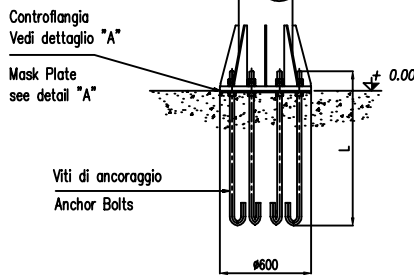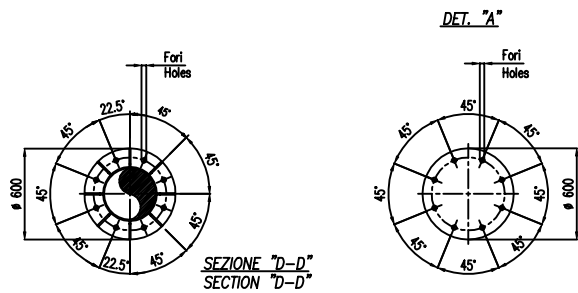

POSIZIONE BOCHELLO  
NOZZLE POSITION

0	15.05.00	Emesso - Issued		MP	MB	
Rev.	Date	Description		Drawn	Checked	Approved
CACCIALANZA & C. s.p.a. ANTINCENDIO SICUREZZA ANTINCENDIUMENTO SEGRATE (MILANO) - ITALY			Client / Project			
Date			Title			
Name			PALO H.10m CON MONITORE TIPO A6EL E BOCCH. ELETTRICO ASSIEME GENERALE			
Drawn			POLE H.10m WITH MONITOR A6EL TYPE & FULL FOG ADJ. NOZZLE GENERAL ASSEMBLY			
Checked			Code			
Approved			Rev.			
Code			Sheet			
Sys.			1			
Size			of			
Scale			0			
Dwg nr.			1			
A2			06977114			
1:25			0			

PALO CON TORRETTA ROTANTE H. 10m + 2m  
POLE WITH ROTATING TOWER H. 10m + 2m

THIS DRAWING IS THE PROPERTY OF CACCIALANZA & C. S.p.A. AND IS NOT TO BE REPRODUCED OR USED TO FURNISH ANY INFORMATION FOR MAKING OF DRAWINGS OR APPARATUS EXCEPT WHERE PROVIDED FOR BY AGREEMENT WITH SAID COMPANY