


Monitore tipo A4 EL
con bocchello elettrico tipo FOG



Electric monitor A4-EL type
with FULL-FOG jet adj. nozzle

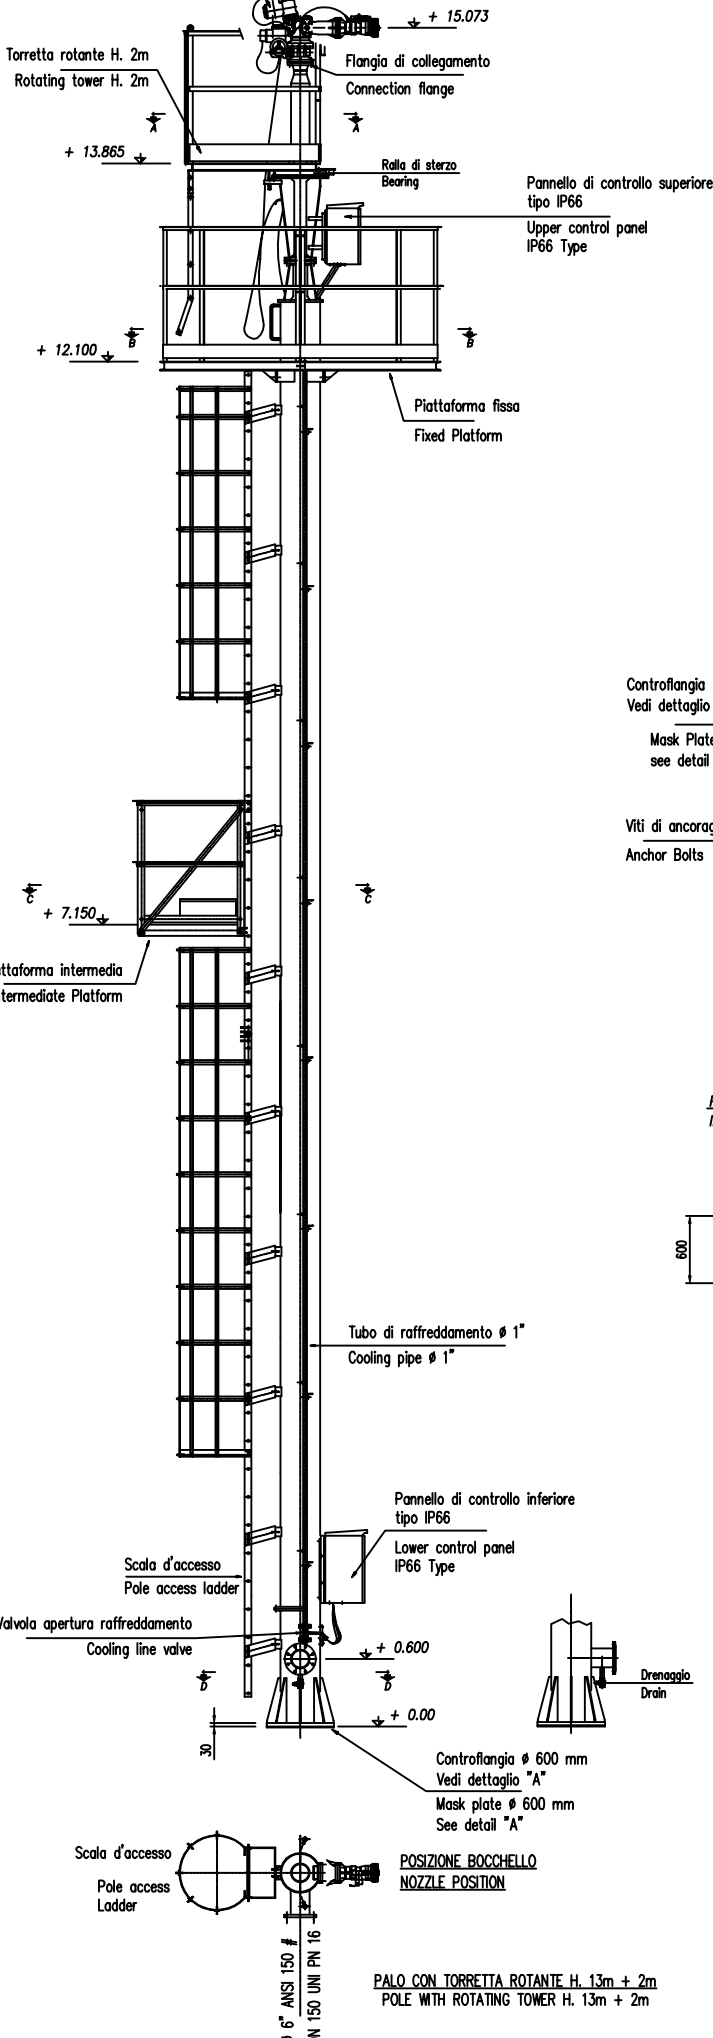

IMPORTANTE :
CACCIALANZA & C. S.p.A. si riserva il diritto di modificare senza preavviso le informazioni contenute su questo scheda con il proposito di apportare miglioramenti alla produzione


IMPORTANT :
CACCIALANZA & C. S.p.A. reserves the right to change or modify without previous notice any data or specification due to changes or modification in order to improve the products presented

DET. "A"

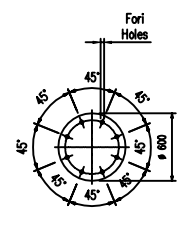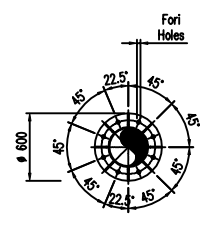


SEZIONE "A-A"
SECTION "A-A"

TORRETTA ROTANTE (TIPICA)
ROTARY TURRET (TYPICAL)

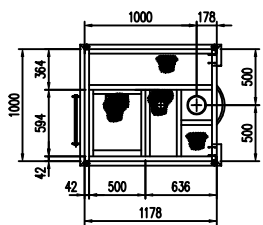


SEZIONE "B-B"
SECTION "B-B"

PIATTAFORMA FISSA (TIPICA)
FIXED PLATFORM (TYPICAL)

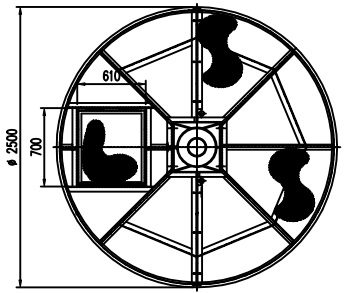

SEZIONE "C-C"
SECTION "C-C"

PIATTAFORMA INTERMEDIA (TIPICA)
INTERMEDIATE PLATFORM (TYPICAL)

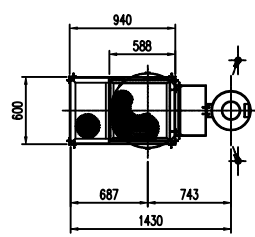

0	10.05.2000	Emesso - Issued	MS	MB	
Rev.	Date	Description	Drawn	Checked	Approved
CACCIALANZA & C. s.p.a. ANTINCENDIO SIOFREZZA ANTINCENDIAMENTO SEGRATE (MILANO) - ITALY			Client / Project		
Drawn	Date	Name	Title		
Checked	10.05.00	M. SPADA	PALO H.13m CON MONITORE TIPO A4EL E BOCCH. ELETTRICO ASSIEME GENERALE		
Approved	10.05.00	M. BARBERI	POLE H.13m WITH MONITOR A4EL TYPE & FULL FOG ADJ. NOZZLE GENERAL ASSEMBLY		
Code	Sys.	Size	Scale	Dwg nr.	Rev.
		A2	1:33.3	06977612	0
					Sheet 1
					of 1

THIS DRAWING IS THE PROPERTY OF CACCIALANZA & C. S.p.A. AND IS NOT TO BE REPRODUCED OR USED TO FURNISH ANY INFORMATION FOR MAKING OF DRAWINGS OR APPARATUS EXCEPT WHERE PROVIDED FOR BY AGREEMENT WITH SAID COMPANY