


**IMPORTANTE :**

CACCIALANZA & C. S.p.A. si riserva il diritto di modificare senza preavviso le informazioni contenute su questa scheda con il proposito di apportare miglioramenti alla produzione

**IMPORTANT :**

CACCIALANZA & C. S.p.A. reserves the right to change or modify without previous notice any data or specification due to changes or modification in order to improve the products presented

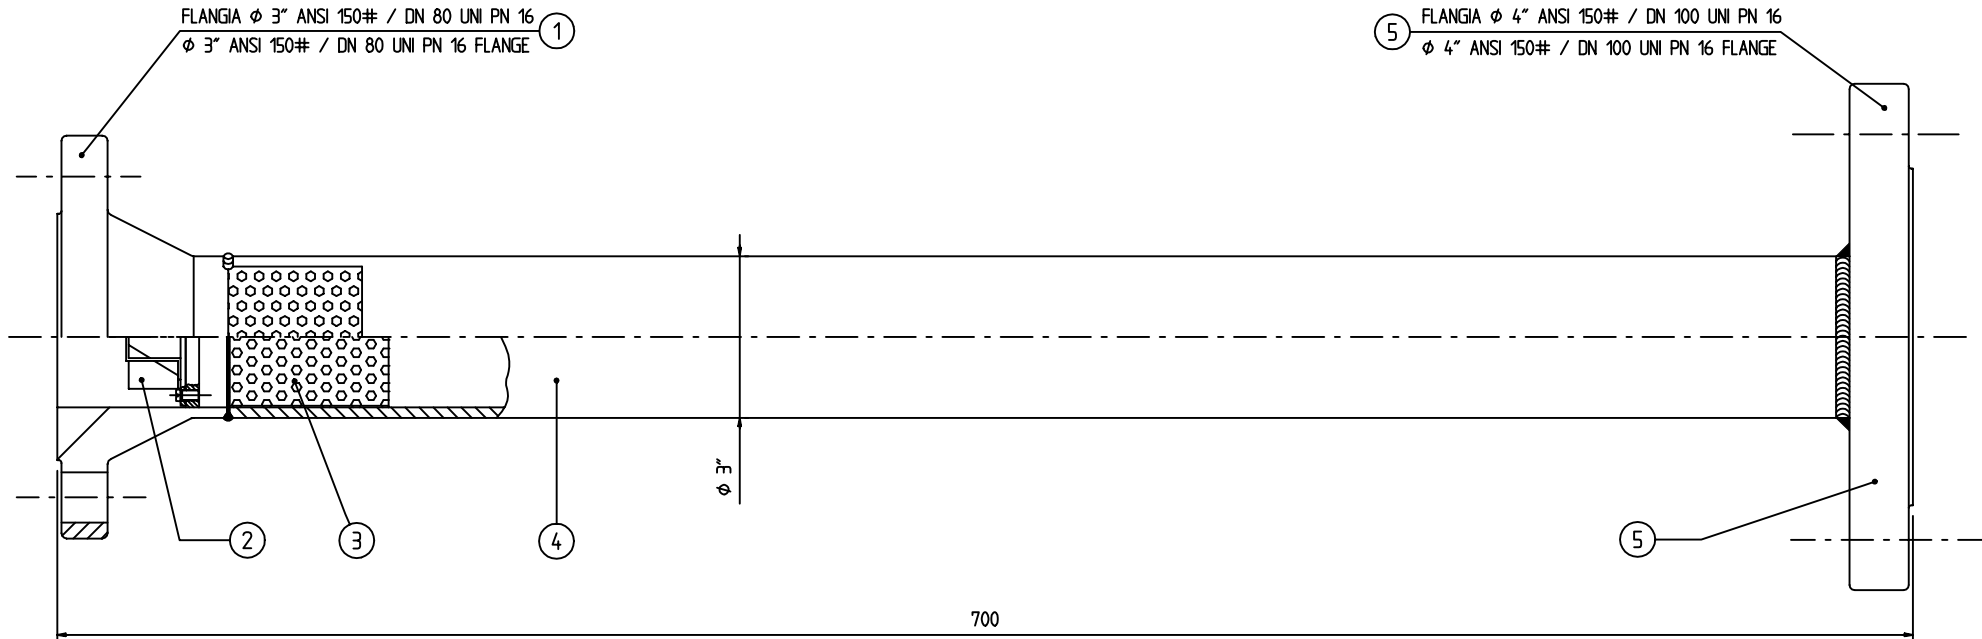

5	FLG. USCITA OUTLET FLANGE	1	A19620012U	ACCIAIO AL CARBONIO CARBON STEEL
4	TUBO PIPE	1	A19620012U	ACCIAIO AL CARBONIO CARBON STEEL
3	LAMIERA FORATA PUNCHED PLATE	1	A19620012U	ACCIAIO INOX STAINLESS STEEL
2	ELICHETTA NOZZLE	1	A19620011T	ACCIAIO INOX STAINLESS STEEL
1	FLG. INGRESSO INLET FLANGE	1	A19620012U	ACCIAIO AL CARBONIO CARBON STEEL
Pos	Descrizione Description	Q.ta Qty	Disegno Drawing	Materiale Material

0	11.10.96	Emesso - Issued		MB	MB	
Rev.	Date	Description	Drawn	Checked	Approved	
CACCIALANZA & C. S.p.A. ANTINCENDIO SICUREZZA ANTINQUINAMENTO SEGRATE (MILANO) - ITALY		Client / Project				
Date		Name		Title		
Drawn	11.10.96	MB		LANCIA SCHIUMA TIPO L8-ST ASSIEME GENERALE FOAM MAKERS L8-ST TYPE GENERAL ASSEMBLY		
Checked	11.10.96	MB				
Approved						
Code	Sys.	Size	Scale	Dwg nr.	Rev.	Sheet
		A3	1:2	19620019	0	1
					of	1
THIS DRAWING IS THE PROPERTY OF CACCIALANZA & C. S.p.A. AND IS NOT TO BE REPRODUCED OR USED TO FURNISH ANY INFORMATION FOR MAKING OF DRAWINGS OR APPARATUS EXCEPT WHERE PROVIDED FOR BY AGREEMENT WITH SAID COMPANY						