


**IMPORTANTE :**

CACCIALANZA & C. S.p.A. si riserva il diritto di modificare senza preavviso le informazioni contenute su questa scheda con il proposito di apportare miglioramenti alla produzione

**IMPORTANT :**

CACCIALANZA & C. S.p.A. reserves the right to change or modify without previous notice any data or specification due to changes or modification in order to improve the products presented

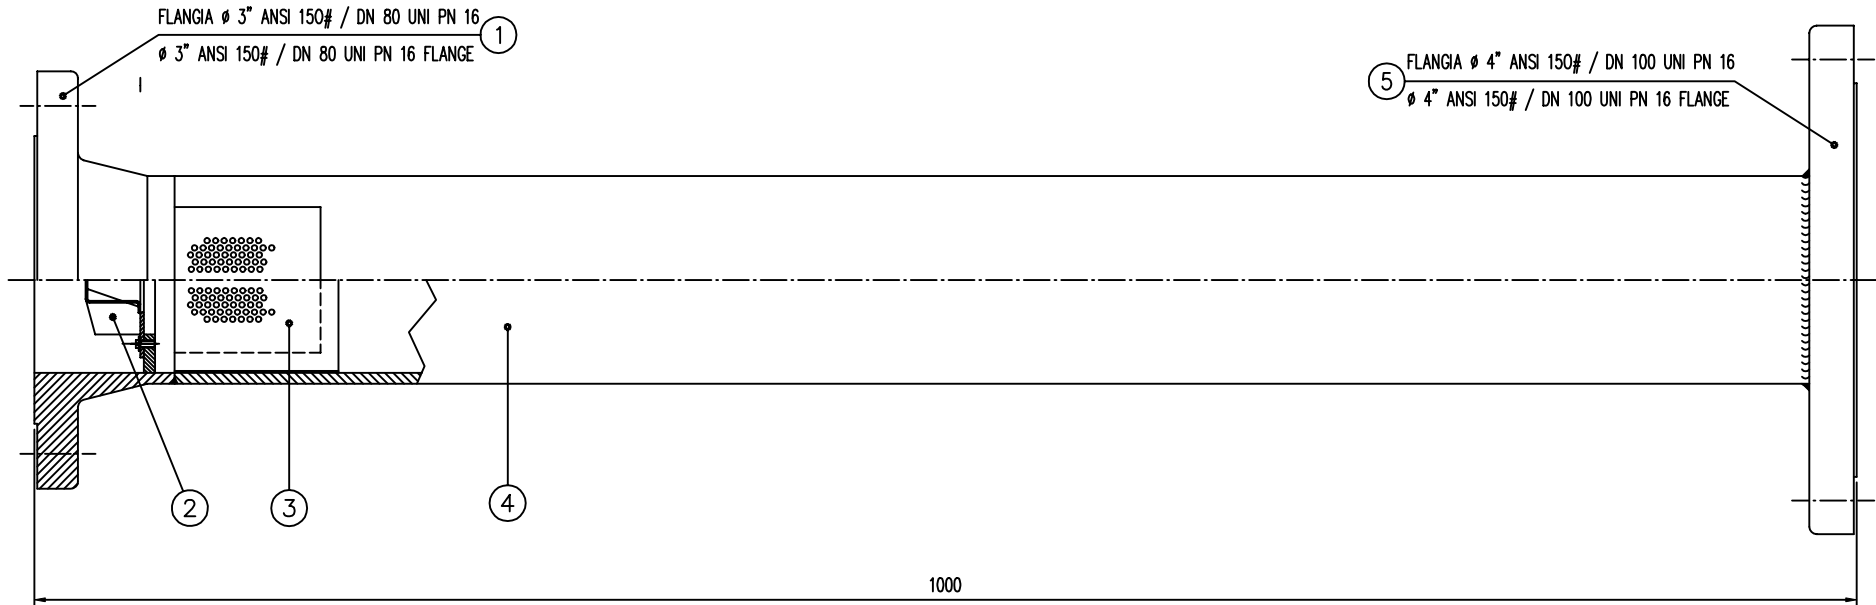

| Pos. | Descrizione<br>Description                         | Q.ty | Materiale<br>Material                           | Code<br>Drawing | Note |
|------|--|------|---|-----------------|------|
| 5    | Flangia di uscita<br>Outlet flange                 | 1    | Acc. carb. ASTM A105<br>C. steel ASTM A105      |                 |      |
| 4    | Tubo $\phi$ 4" sch. std<br>Pipe $\phi$ 4" sch. std | 1    | API 5L Gr. B<br>API 5L Gr. B                    |                 |      |
| 3    | Lamiera forata<br>Punched plate                    | 1    | Acciaio inox AISI304<br>Stainless steel AISI304 |                 |      |
| 2    | Elichetta<br>Nozzle                                | 1    | Acciaio inox AISI304<br>Stainless steel AISI304 |                 |      |
| 1    | Flangia di ingresso<br>Inlet flange                | 1    | Acc. carb. ASTM A105<br>C. steel ASTM A105      |                 |      |

| Rev.   | Date       | Description      | Drawn | Checked   | Approved |
|--|------------|------------------|-------|---|----------|
| 0  | 11.10.1996 | Emesso - Issued  | MB    | MB  |          |
| CACCIALANZA & C. s.p.a.<br>ANTINCENDIO SICUREZZA ANTINQUINAMENTO<br>SEGRATE (MILANO) - ITALY |            | Client / Project |       |   |          |
| Date   |            | Name             |       | Title   |          |
| Drawn  | 11.10.96   | M. BARBIERI      |       | LANCIA SCHIUMA TIPO L12ST<br>ASSIEME GENERALE<br>FOAM MAKERS L12ST TYPE<br>GENERAL ASSEMBLY |          |
| Checked  | 11.10.96   | M. BARBIERI      |       |   |          |
| Approved   |            |                  |       |   |          |
| Code   | 1974046000 | Sys.             | Size  | Scale   | Dwg nr.  |
|  |            |                  | A3    | /   | 19630015 |
|  |            |                  |       | Rev.  | Sheet    |
|  |            |                  |       | 0   | 1        |
|  |            |                  |       | of  | 1        |

THIS DRAWING IS THE PROPERTY OF CACCIALANZA & C. S.p.A. AND IS NOT TO BE REPRODUCED OR USED TO FURNISH ANY INFORMATION FOR MAKING OF DRAWINGS OR APPARATUS EXCEPT WHERE PROVIDED FOR BY AGREEMENT WITH SAID COMPANY