


**IMPORTANTE :**  
 CACCIALANZA & C. S.p.A. si riserva il diritto di modificare senza preavviso le informazioni contenute su questa scheda con il proposito di apportare miglioramenti alla produzione

**IMPORTANT :**  
 CACCIALANZA & C. S.p.A. reserves the right to change or modify without previous notice any data or specification due to changes or modification in order to improve the products presented

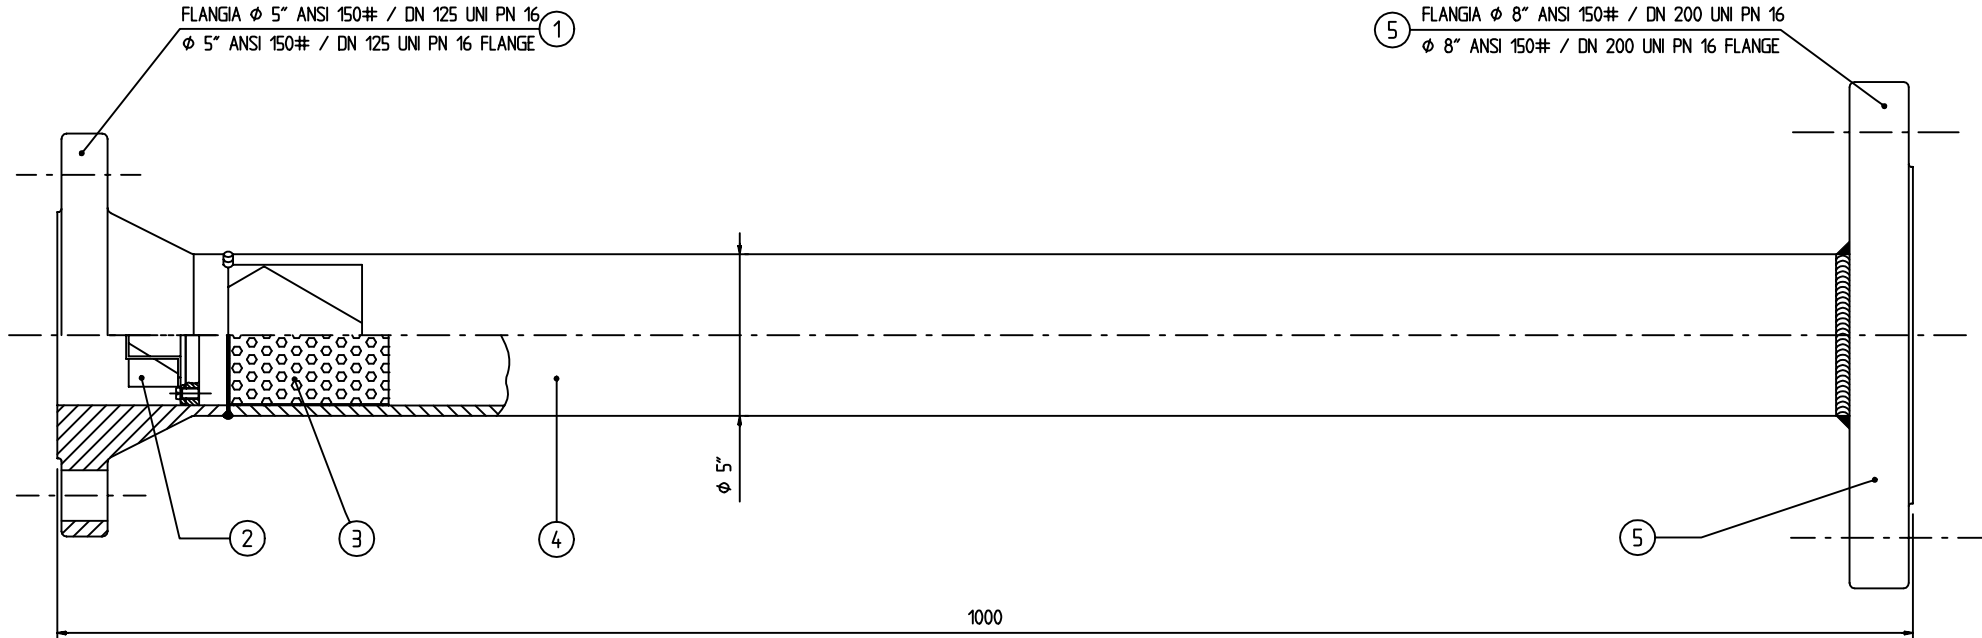

5	FLG. USCITA OUTLET FLANGE	1	A1965001BU	ACCIAIO AL CARBONIO CARBON STEEL
4	TUBO PIPE	1	A1965001BU	ACCIAIO AL CARBONIO CARBON STEEL
3	LAMIERA FORATA PUNCHED PLATE	1	A1965001BU	ACCIAIO INOX STAINLESS STEEL
2	ELICETTA NOZZLE	1	A19650012T	ACCIAIO INOX STAINLESS STEEL
1	FLG. INGRESSO INLET FLANGE	1	A1965001BU	ACCIAIO AL CARBONIO CARBON STEEL
Pos	Descrizione Description	Q.ta Qty	Disegno Drawing	Materiale Material

0	11.10.96	Emesso - Issued	MB	MB	
Rev.	Date	Description	Drawn	Checked	Approved
		<b>CACCIALANZA &amp; C.</b> s.p.a. ANTINCENDIO SICUREZZA ANTINQUINAMENTO SEGRATE (MILANO) - ITALY	Client / Project		
			Title		
			LANCIA SCHIUMA TIPO L20-ST ASSIEME GENERALE PORTABLE FOAM MAKER L20-ST TYPE GENERAL ASSEMBLY		
Drawn	Date		Name		
Checked	11.10.96	MB			
Approved					
Code	Sys.	Size	Scale	Dwg nr.	Rev.
		A3	1:2	19650015	0
					Sheet 1 of 1
THIS DRAWING IS THE PROPERTY OF CACCIALANZA & C. S.p.A. AND IS NOT TO BE REPRODUCED OR USED TO FURNISH ANY INFORMATION FOR MAKING OF DRAWINGS OR APPARATUS EXCEPT WHERE PROVIDED FOR BY AGREEMENT WITH SAID COMPANY					