


IMPORTANTE :

CACCIALANZA & C. Sp.A. si riserva il diritto di modificare senza preavviso le informazioni contenute su questa scheda con il proposito di apportare miglioramenti alla produzione

IMPORTANT :

CACCIALANZA & C. Sp.A. reserves the right to change or modify without previous notice any data or specification due to changes or modification in order to improve the products presented

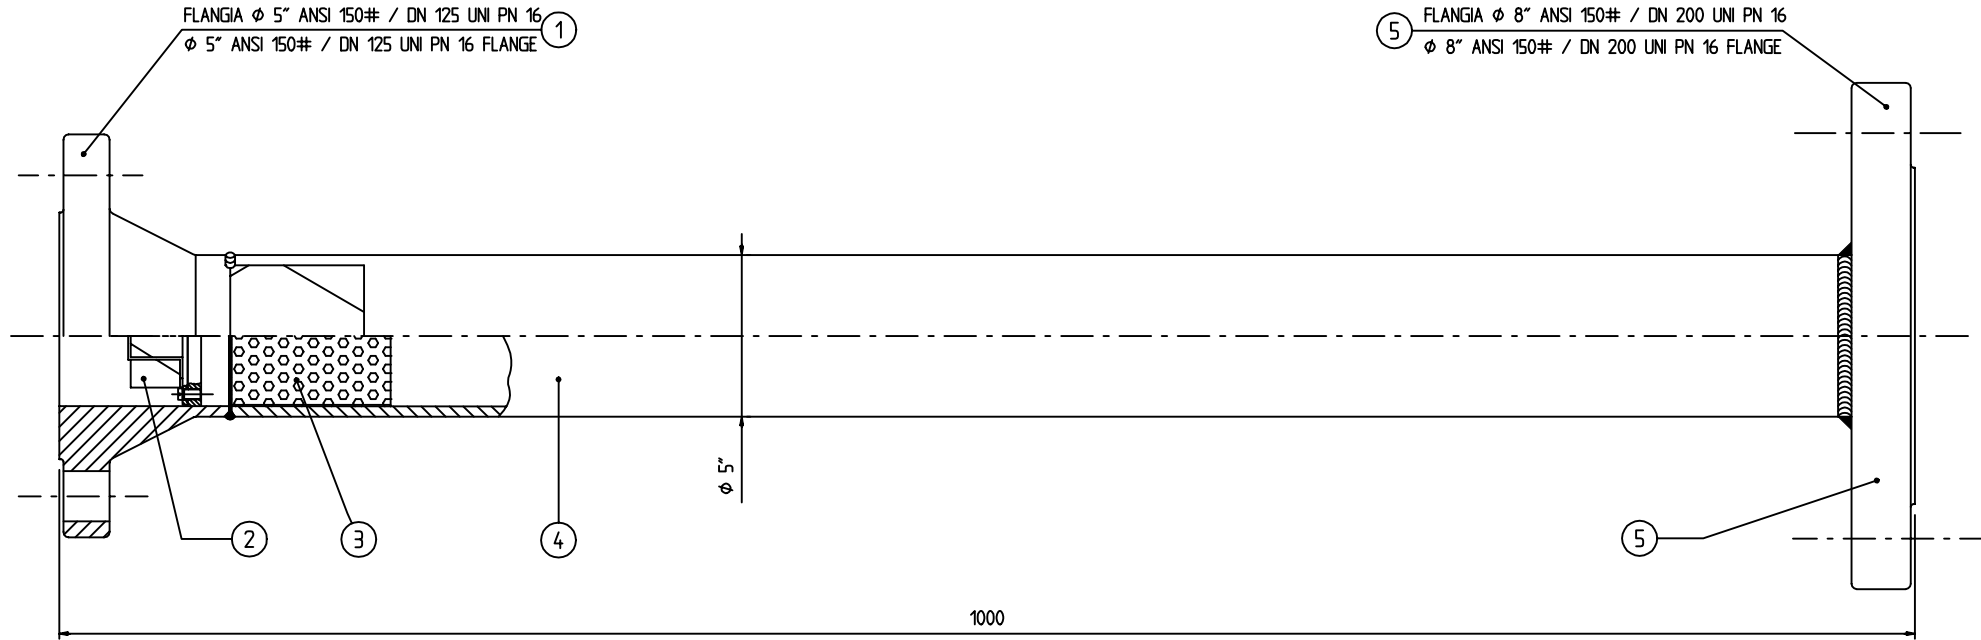

Pos	Descrizione Description	Q.ta Qty	Disegno Drawing	Materiale Material
5	FLG. USCITA OUTLET FLANGE	1	A1965001BU	ACCIAIO AL CARBONIO CARBON STEEL
4	TUBO PIPE	1	A1965001BU	ACCIAIO AL CARBONIO CARBON STEEL
3	LAMIERA FORATA PUNCHED PLATE	1	A1965001BU	ACCIAIO INOX STAINLESS STEEL
2	ELICETTA NOZZLE	1	A19650011T	ACCIAIO INOX STAINLESS STEEL
1	FLG. INGRESSO INLET FLANGE	1	A1965001BU	ACCIAIO AL CARBONIO CARBON STEEL

Rev.	Date	Description	Drawn	Checked	Approved	
0	11.10.96	Emesso - Issued	MB	MB		
<p>CACCIALANZA & C. s.p.a. ANTINCENDIO SICUREZZA ANTINQUINAMENTO SEGRATE (MILANO) - ITALY</p>						
Date		Name	Client / Project			
Drawn	11.10.96	MB	<p>Title LANCIA SCHIUMA TIPO L24-ST ASSIEME GENERALE FOAM MAKERS L24-ST TYPE GENERAL ASSEMBLY</p>			
Checked	11.10.96	MB				
Approved						
Code	Sys.	Size	Scale	Dwg nr.	Rev.	Sheet
		A3	1:2	19650016	0	1 of 1
<p>THIS DRAWING IS THE PROPERTY OF CACCIALANZA & C. Sp.A. AND IS NOT TO BE REPRODUCED OR USED TO FURNISH ANY INFORMATION FOR MAKING OF DRAWINGS OR APPARATUS EXCEPT WHERE PROVIDED FOR BY AGREEMENT WITH SAID COMPANY</p>						