


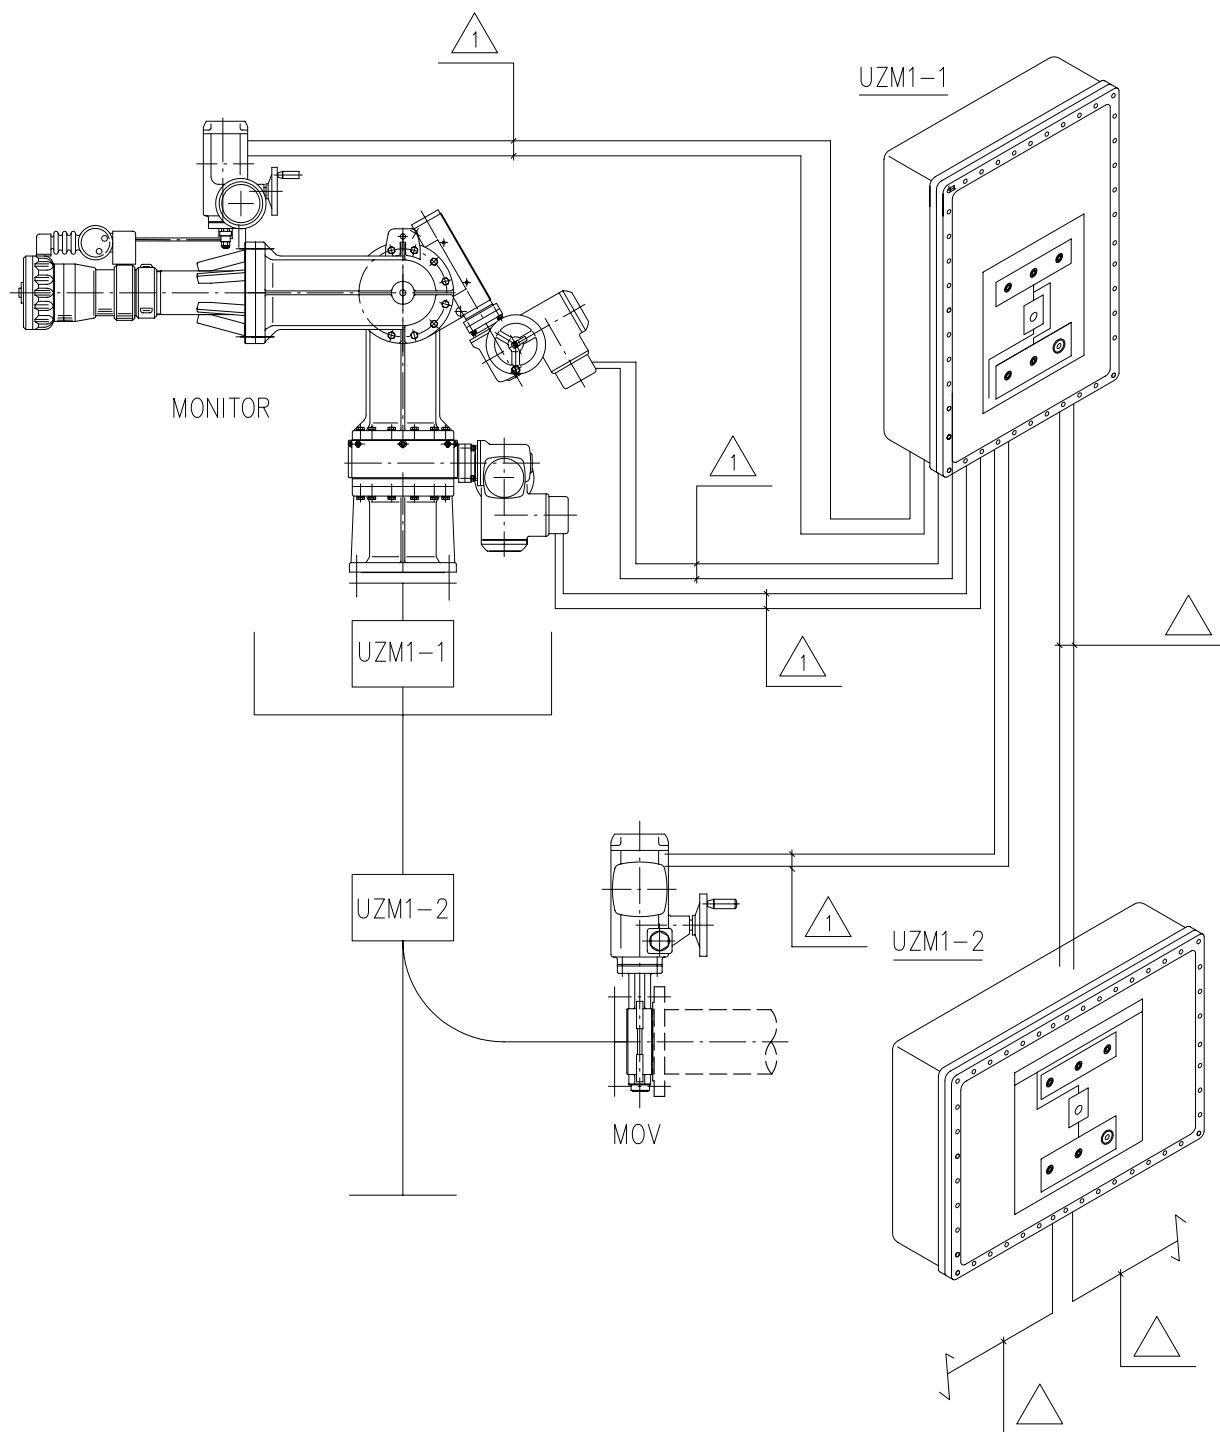

△₁ - (4 x 2.5 mm² + 11 x 1.5 mm²) or special cable CMT3 type

0	09.10.01	Issued	MB	MB	
Rev.	Date	Description	Drawn	Checked	Approved
CACCIALANZA & C. S.p.A. ANTINCENDIO SICUREZZA ANTINQUINAMENTO SEGRATE (MILANO) - ITALY			Title :		
			Dwg nr. 46401001		
			Project nr.		
			Sheet nr. 1 of 1		