 


0	14.09.2001	ISSUED	An.T.	Al.T.	A.M.
Rev.	Date	Description	Drawn	Checked	Approved
CACCIALANZA & C. <small>s.p.A.</small> ANTINCENDIO SICUREZZA ANTINQUINAMENTO SEGRATE (MILAND) - ITALY		Client / Project			
		Title			
	Date	Name	PANEL 1 MONITOR (2 MOV.)		
Drawn	14.09.2001	An.T.	EXECUTION WITH SEPARATE COMMAND BOX		
Checked	14.09.2001	Al.T.			
Approved	14.09.2001	A.M.			
Code	Sys.	Size	Scale	Dwg nr.	Rev.
		A 3	/	46403201	0
					Sheet 1
					of 12
THIS DRAWING IS THE PROPERTY OF CACCIALANZA & C. S.p.A. AND IS NOT TO BE REPRODUCED OR USED TO FURNISH ANY INFORMATION FOR MAKING OF DRAWINGS OR APPARATUS EXCEPT WHERE PROVIDED FOR BY AGREEMENT WITH SAID COMPANY					

a b c d e f g h i j k m n p q r

0
1
2
3
4
5
6
7
8
9

PANEL BOARD TECHNICAL DATA		
RATED SERVICE VOLTAGE:.....400V	TYPE OF SEGREGATION:.....FORM 1	TEMPERATURE:.....40°C
RATED INSULATION VOLTAGE:.....1000V	INSTALLATION:.....OUTDOOR	DEGREE OF PROTECTION:.....IP65
RATED FREQUENCY:.....50Hz	COMPLIANCE WITH STANDARD:.....CEI 17/13.1	COLOR:.....RED RAL3000
ELECTRICAL SYSTEM:.....3Ph+PE	IN/OUT CABLES:.....BOTTOM	

CACCIALANZA & C. s.p.a
 ANTINCENDIO SICUREZZA ANTINQUINAMENTO
 SEGRATE (MILANO) - ITALY

TITLE
MONITOR 2 MOTIONS
 TYPE A2-A4-A6-A8/EL


CLIENT

			DATE	14.09.2001	DWG N°	46403201
			SCALE	/		
			DRAWN	An.T.	PROJECT N°	
0	ISSUED	14.09.01	CHECKED	ALT.		
REV.	MODIFY	DATE	APPROVED	A.M.	SHEET N°	3 OF 12

a b c d e f g h i j k m n p q r

0
1
2
3
4
5
6
7
8
9

POWER CIRCUIT		AUXILIARY CIRCUIT	
MIN. SECTION 2,5mmq		MIN. SECTION 1,5mmq	
CONDUCTOR		CONDUCTOR	
PHASES	BLACK	24V - C.A.	RED
NEUTRAL	LIGHT BLUE	110V - A.C	RED
GROUND	YELLOW-GREEN	220V - A.C	BLACK
		24V - D.C	BLUE
WIRE COLOUR TABLE			

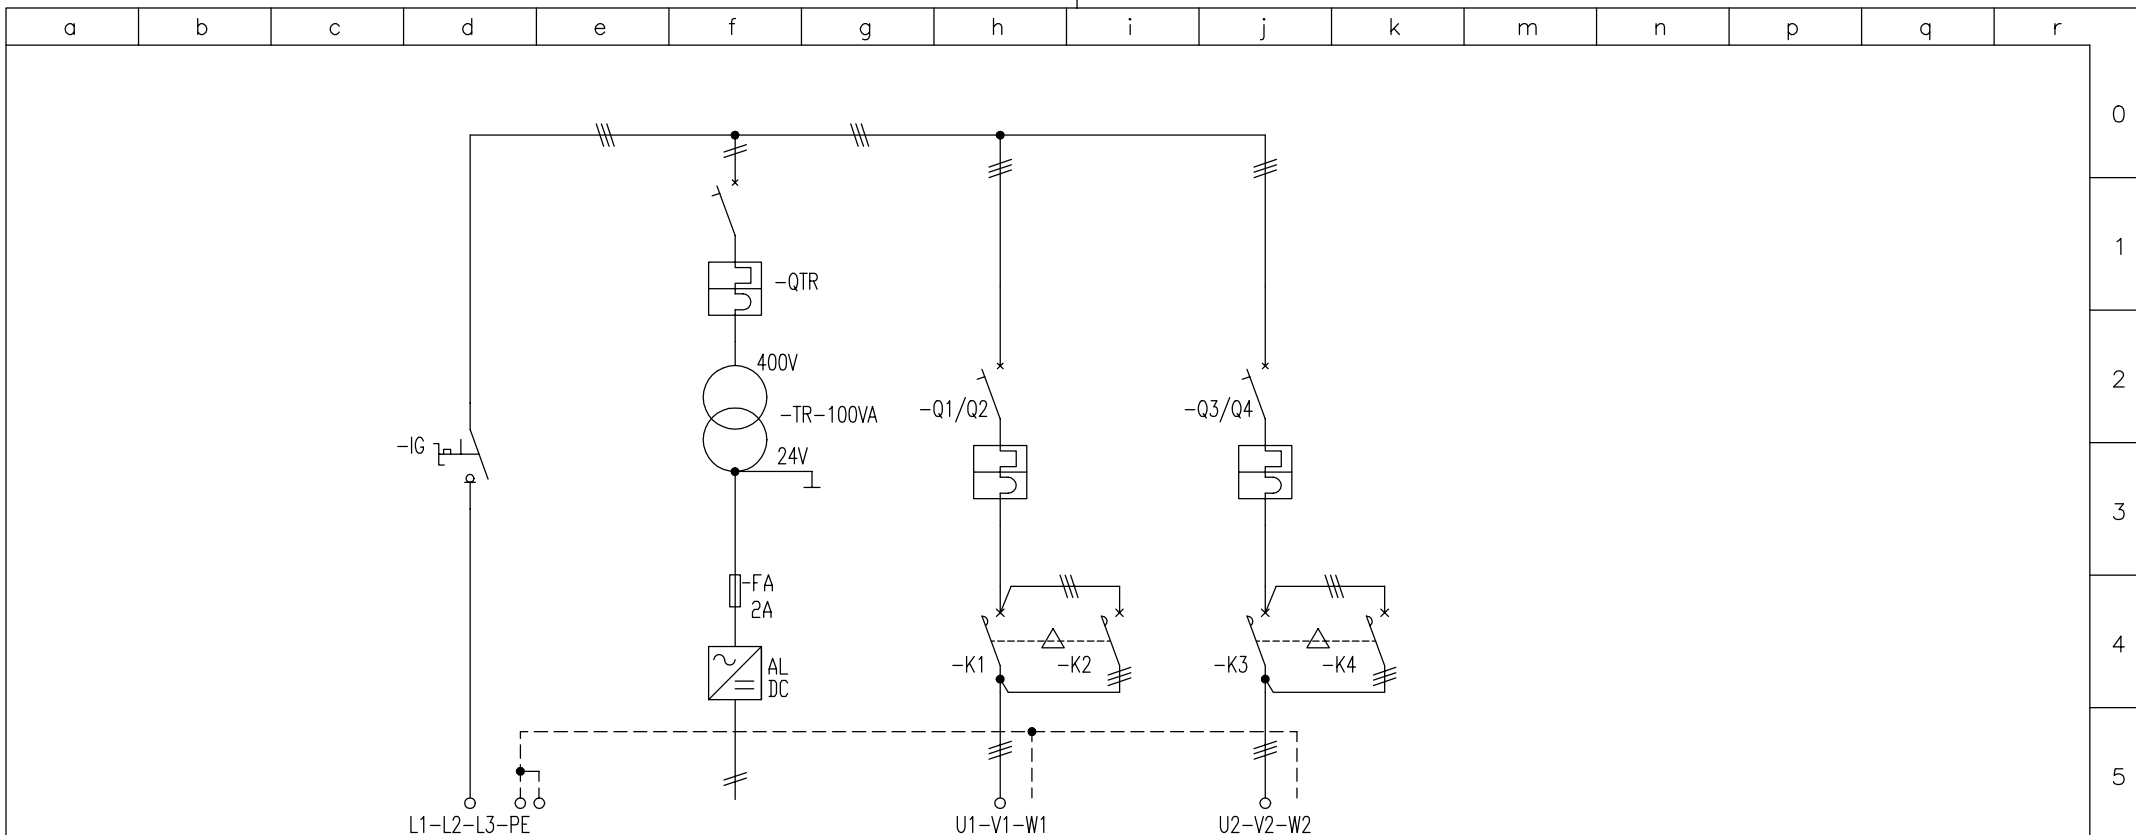

USE	CIRCUIT		n?		MAIN SUPPLY		RIGHT/LEFT MONITOR MO1.1		UP/DOWN MONITOR MO1.2	
	DESCRIPTION		Kw	A	1	2	0,45	0,9	0,45	0,9
ELECTRICAL EQUIPMENT	RATED SERVICE POWER AND CURRENT		Kw	A						
			Kw	A	1	2	0,45	0,9	0,45	0,9
	SWITCH	TYPE			P1-25	Z			
		RATED CURRENT - N. POLES	A	n?	25	3				
		BREAKING CAPACITY	V	KA	400					
		SETTING CURRENT MAG. ELEMENT			A					
		SETTING CURRENT THE. ELEMENT			A					
	CON-FACTOR	SETTING CURRENT Id			A					
		TYPE				DILER40//G(24VDC)	DILER40/G(24VDC)			
		RATED CURRENT			A					
THERMAL RELAY	UTILIZATION CATEGORY				AC-3	AC-3				
	TYPE									
	SETTING RANGE			A						
	SETTING CURRENT			A						
FUSEHOLDER	- TYPE & CURRENT		A							
	- TYPE & SETTING CURRENT		A							
LINE	AMMETER									
	VOLTMETER									
CABLE	TYPE									
	SECTION	mmq		(4G2,5)						
	LANCE	mt		(4G2,5)						
	RATED CURRENT(Iz)	A								


CACCIALANZA & C. s.p.a
 ANTINCENDIO SICUREZZA ANTINQUINAMENTO
 SEGRATE (MILAND) - ITALY

TITLE
MONITOR 2 MOTIONS
 TYPE A2-A4-A6-A8/EL

CLIENT

DATE	14.09.2001	DWG N°	46403201
SCALE	/	PROJECT N°	
DRAWN	An.T.	CHECKED	AL.T.
0 ISSUED	14.09.01	APPROVED	A.M.
REV.	MODIFY	DATE	APPROVED A.M.

a b c d e f g h i j k m n p q r

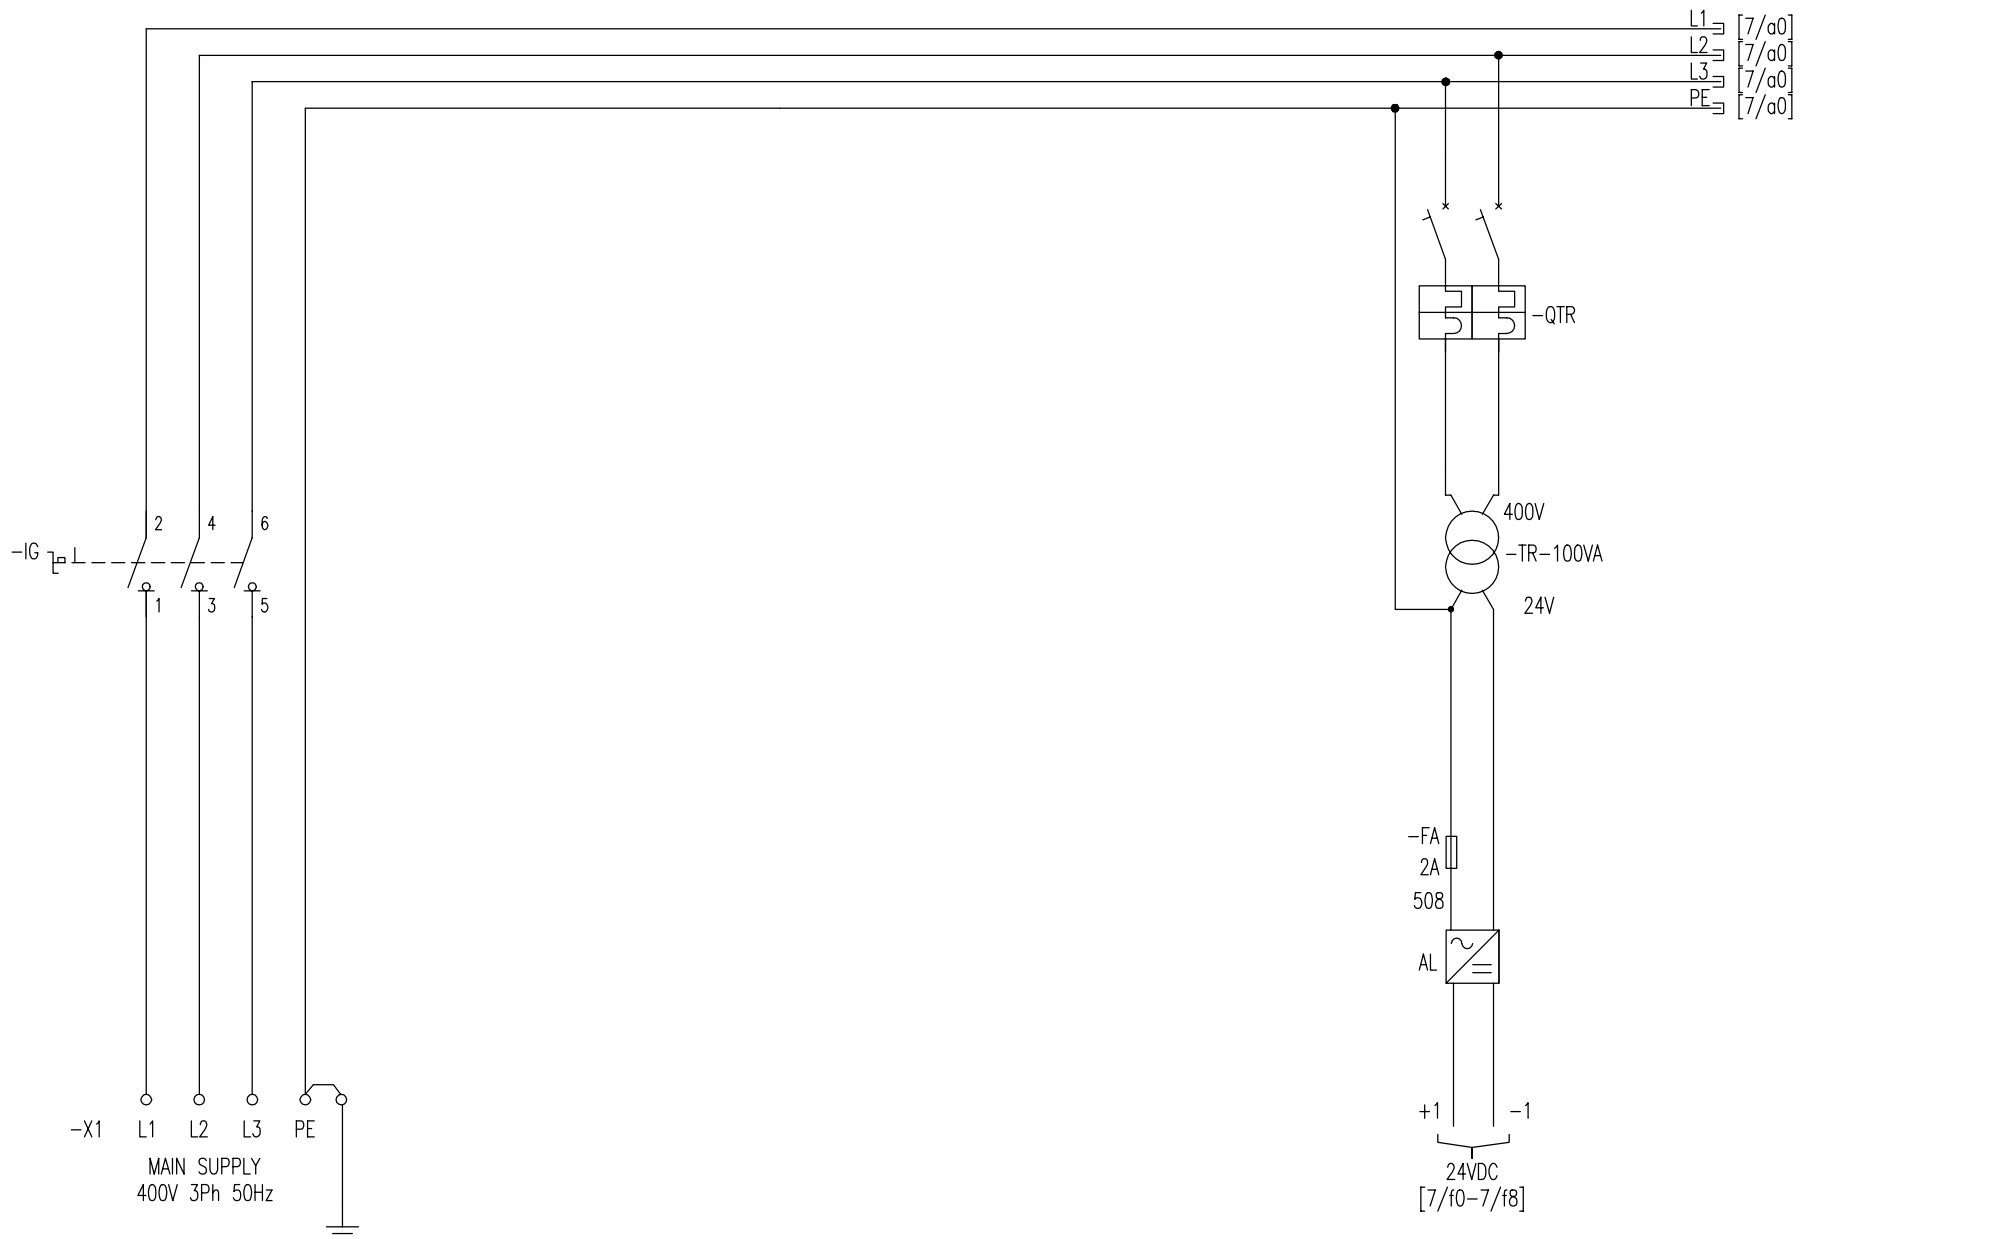


0
1
2
3
4
5
6
7
8
9

CACCIALANZA & C. s.p.a.
ANTINCENDIO SICUREZZA ANTINQUINAMENTO
SEGRATE (MILANO) - ITALY

TITLE
MONITOR 2 MOTIONS
TYPE A2-A4-A6-A8/EL

CLIENT

			DATE	14.09.2001	DWG N°	46403201
			SCALE	/	PROJECT N°	
			DRAWN	An.T.		
0	ISSUED	14.09.01	CHECKED	AL.T.		
REV.	MODIFY	DATE	APPROVED	A.M.	SHEET N°	6 OF 12

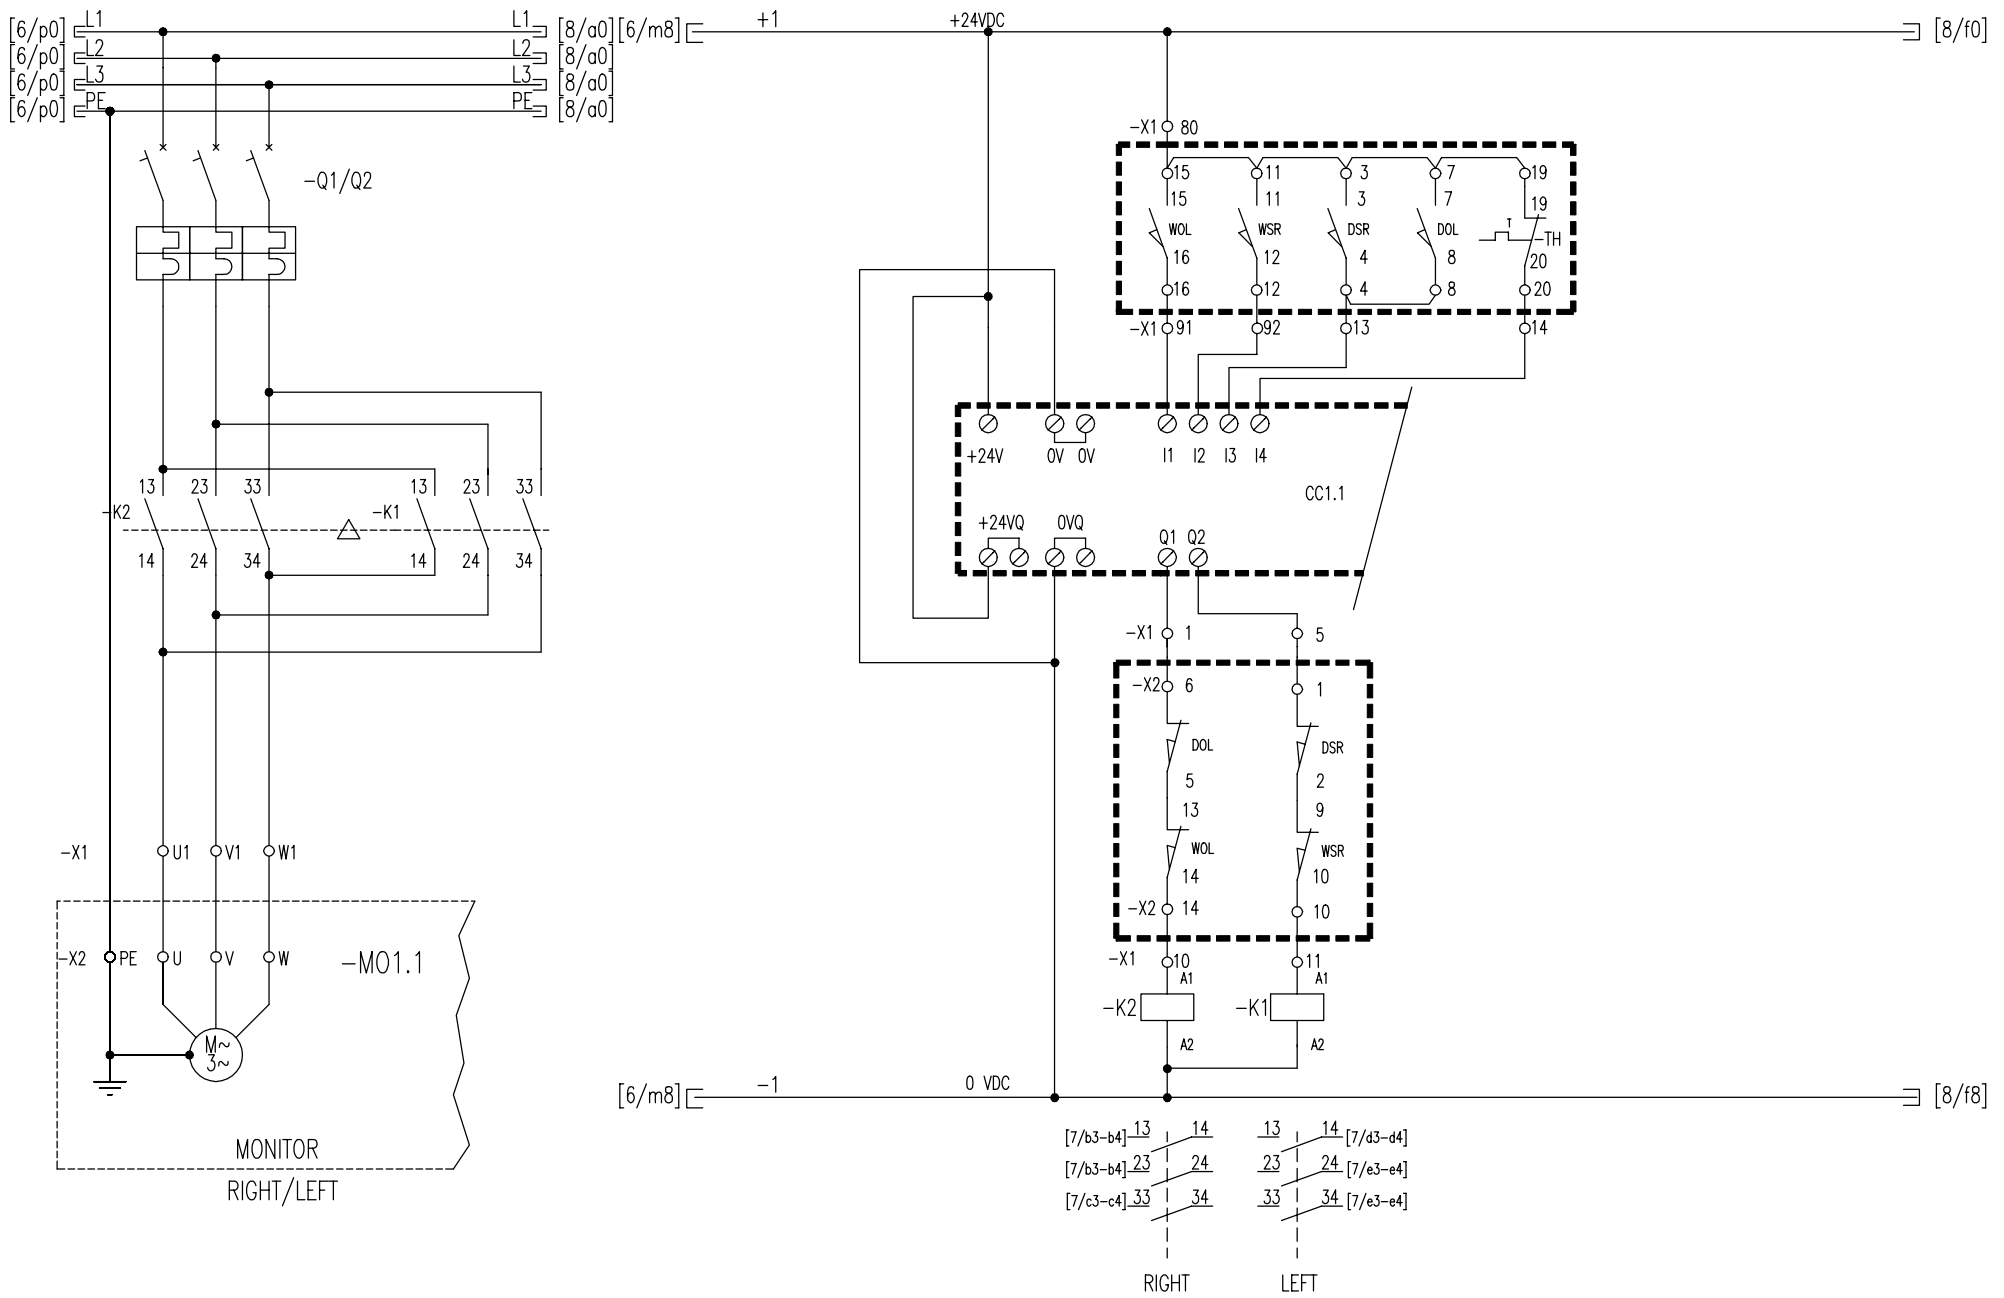



CACCIALANZA & C. s.p.a.
ANTINCENDIO SICUREZZA ANTINQUINAMENTO
SEGRATE (MILANO) - ITALY

TITLE
MONITOR 2 MOTIONS
TYPE A2-A4-A6-A8/EL

CLIENT

DATE	14.09.2001
SCALE	/
DRAWN	An.T.
CHECKED	AL.T.
APPROVED	A.M.
REV.	MODIFY
DATE	14.09.01

DWG N° 46403201
PROJECT N°
SHEET N. 7 OF 12

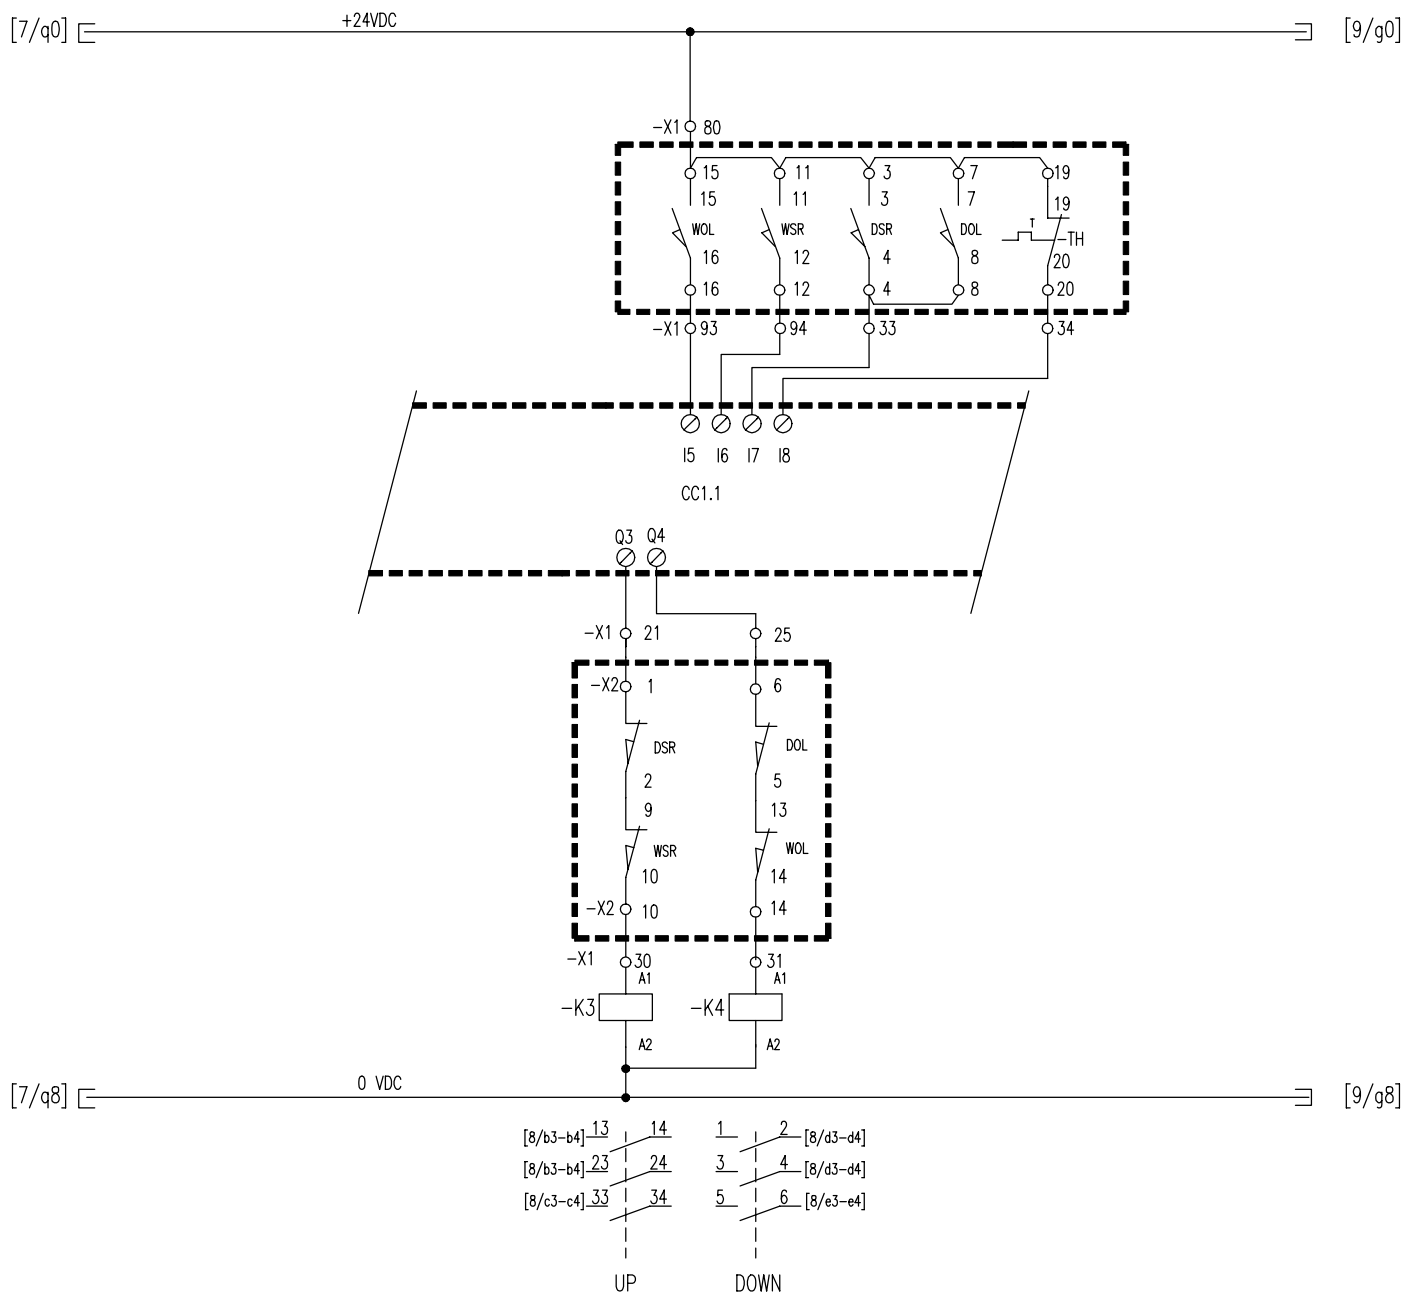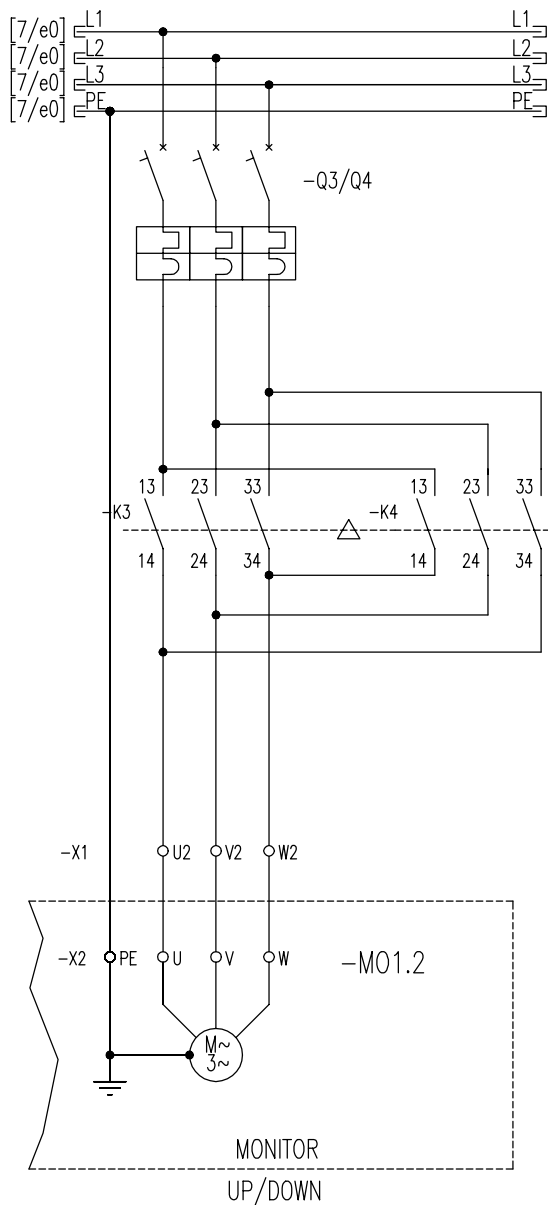


CACCIALANZA & C. s.p.a.
ANTINCENDIO SICUREZZA ANTINQUINAMENTO
SEGRATE (MILANO) - ITALY

TITLE
MONITOR 2 MOTIONS
TYPE A2-A4-A6-A8/EL

CLIENT

DATE	14.09.2001
SCALE	/
DRAWN	An.T.
CHECKED	AL.T.
APPROVED	A.M.
REV.	MODIFY
DATE	14.09.01

DWG N° 46403201
PROJECT N°
SHEET N. 8 OF 12

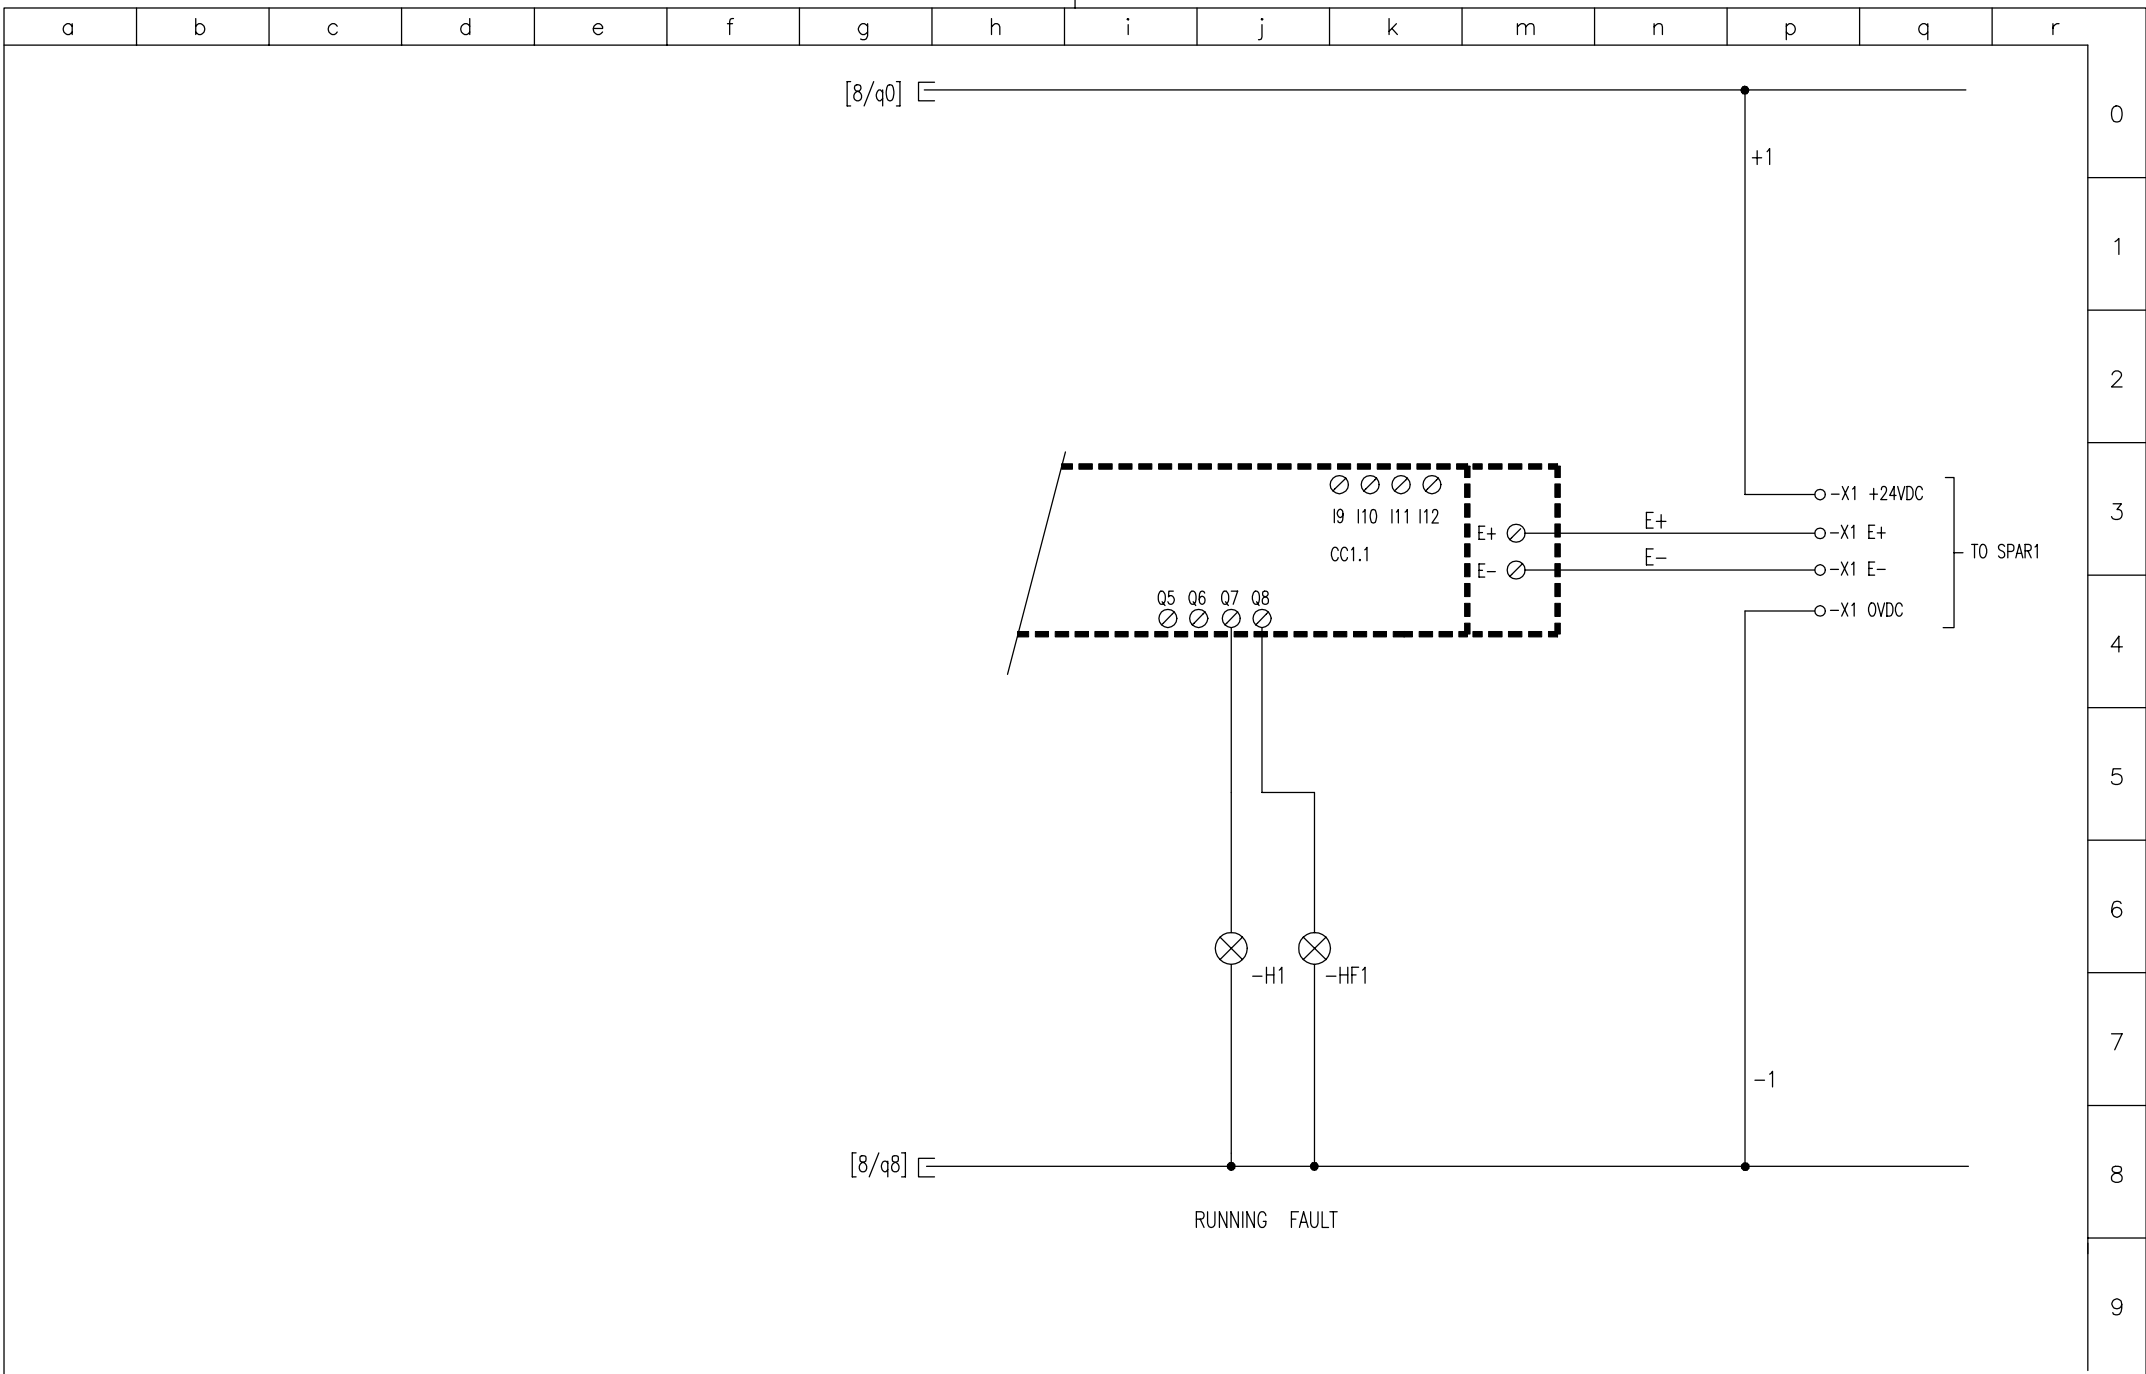

0
1
2
3
4
5
6
7
8
9

CACCIALANZA & C. s.p.a.
ANTINCENDIO SICUREZZA ANTINQUINAMENTO
SEGRATE (MILANO) - ITALY

TITLE
MONITOR 2 MOTIONS
TYPE A2-A4-A6-A8/EL


CLIENT

DATE	14.09.2001
SCALE	/
DRAWN	An.T.
CHECKED	ALT.
APPROVED	A.M.
REV.	MODIFY
DATE	14.09.01
ISSUED	0

DWG N° **46403201**

PROJECT N°

SHEET N° 9 OF 12

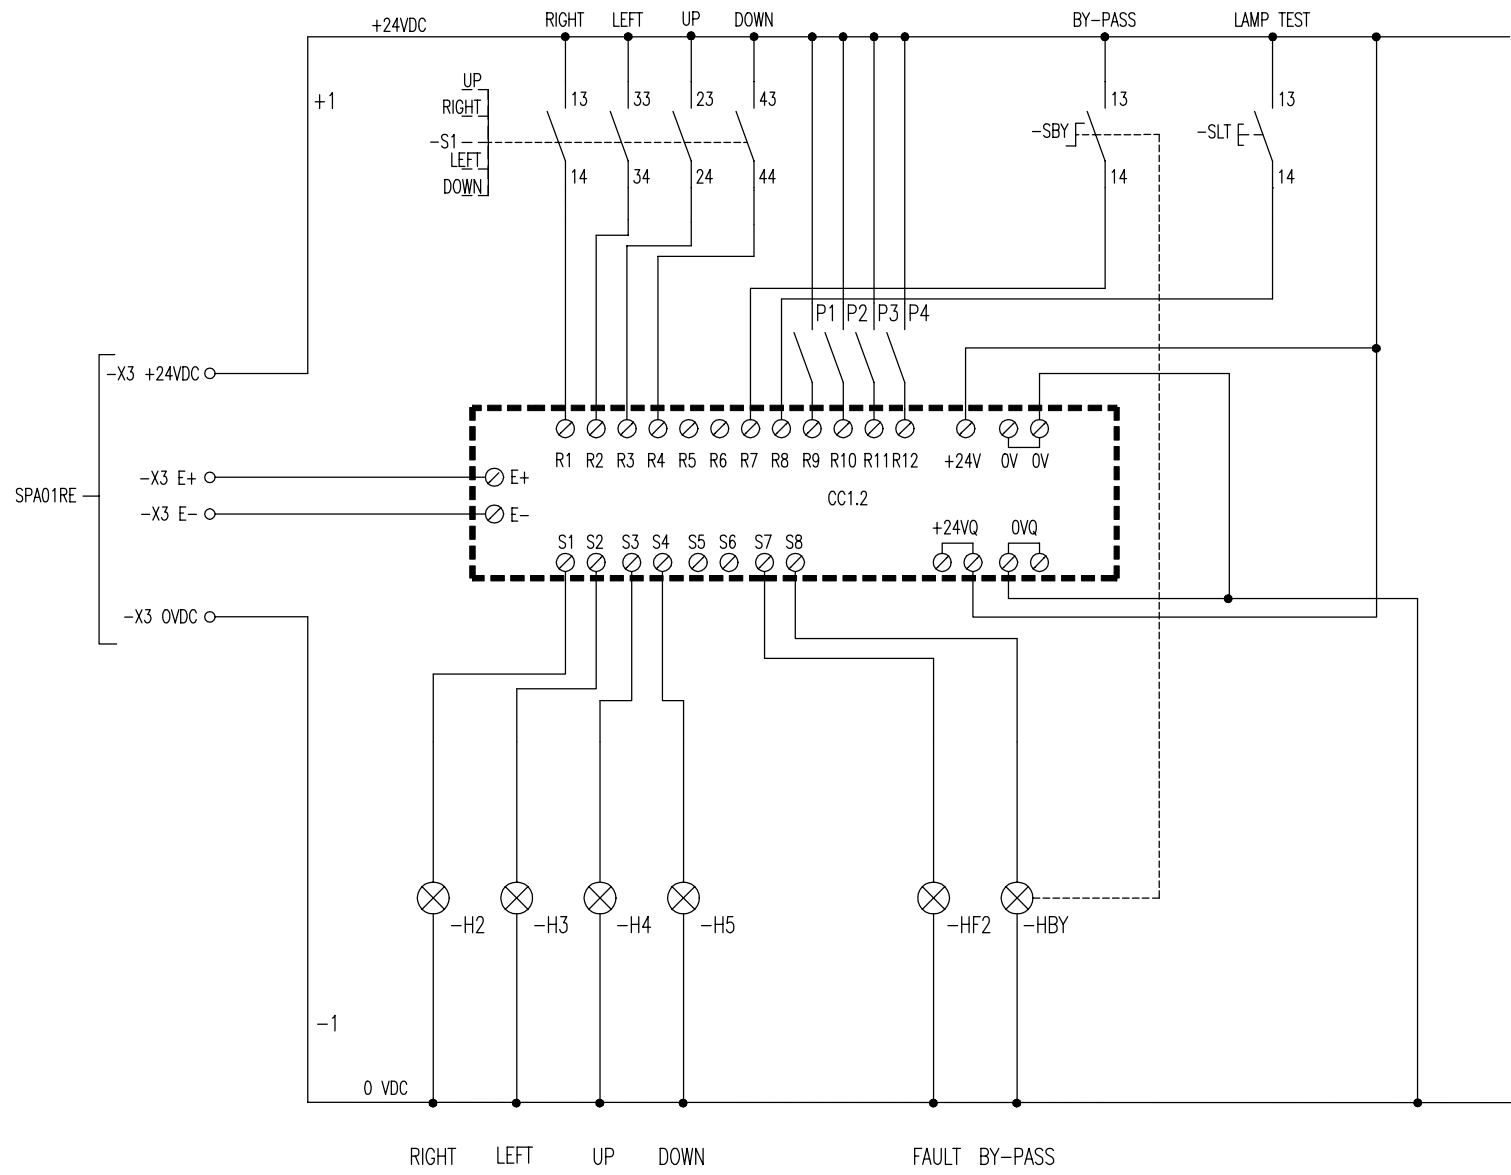

CACCIALANZA & C. S.p.A.
 ANTINCENDIO SICUREZZA ANTINQUINAMENTO
 SEGRATE (MILANO) - ITALY

TITLE
MONITOR 2 MOTIONS
 TYPE A2-A4-A6-A8/EL

CLIENT

DATE	14.09.2001
SCALE	/
DRAWN	An.T.
CHECKED	ALT.
DATE	14.09.01
APPROVED	A.M.

DWG N° **46403201**


PROJECT N°

SHEET N°. 10 OF 12

0	ISSUED	14.09.01	CHECKED	ALT.
REV.	MODIFY	DATE	APPROVED	A.M.

a b c d e f g h i j k m n p q r

0
1
2
3
4
5
6
7
8
9

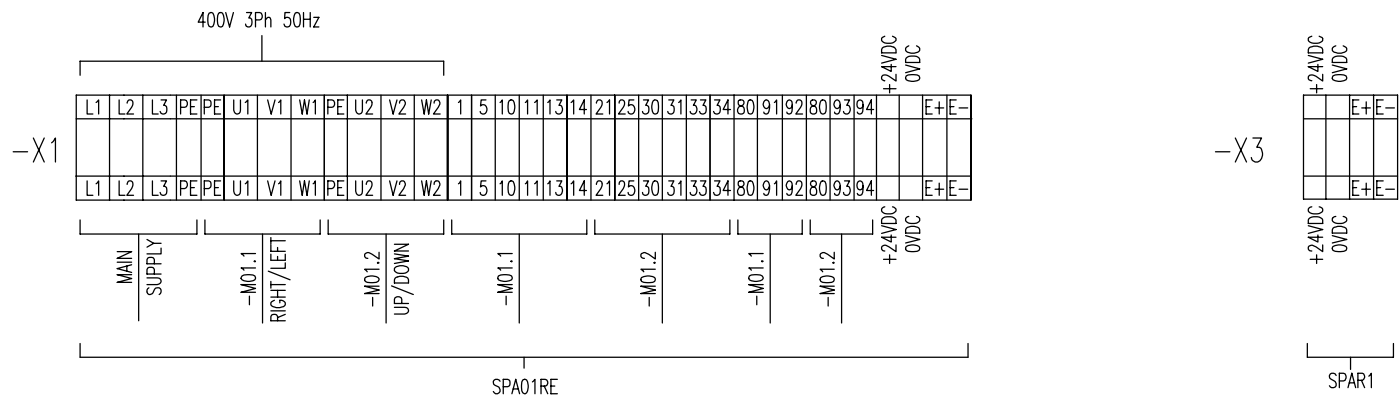

CACCIALANZA & C. s.p.a.
ANTINCENDIO SICUREZZA ANTINQUINAMENTO
SEGRATE (MILANO) - ITALY

TITLE
MONITOR 2 MOTIONS
TYPE A2-A4-A6-A8/EL

CLIENT

DATE	14.09.2001
SCALE	/
DRAWN	An.T.
CHECKED	AL.T.
DATE	APPROVED
APPROVED	A.M.


DWG N° 46403201

PROJECT N°


SHEET N° 11 OF 12

0	ISSUED	14.09.01
REV.	MODIFY	DATE

SPA01RE

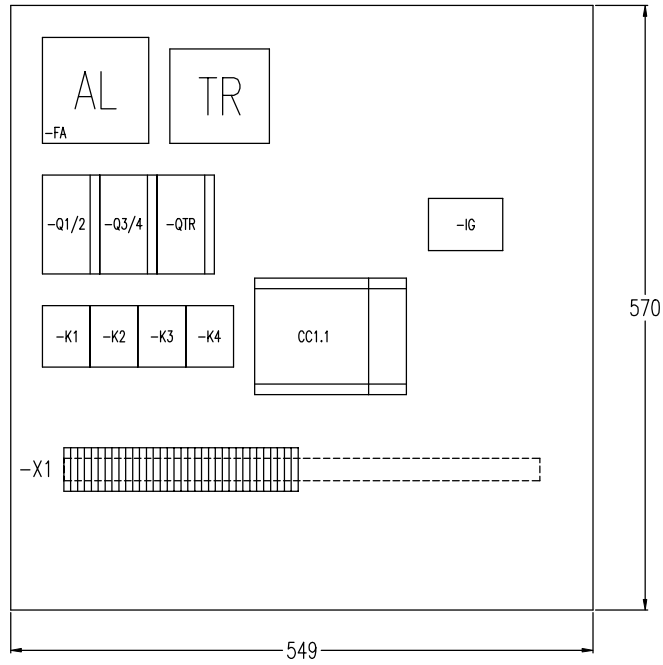


SPA01RE

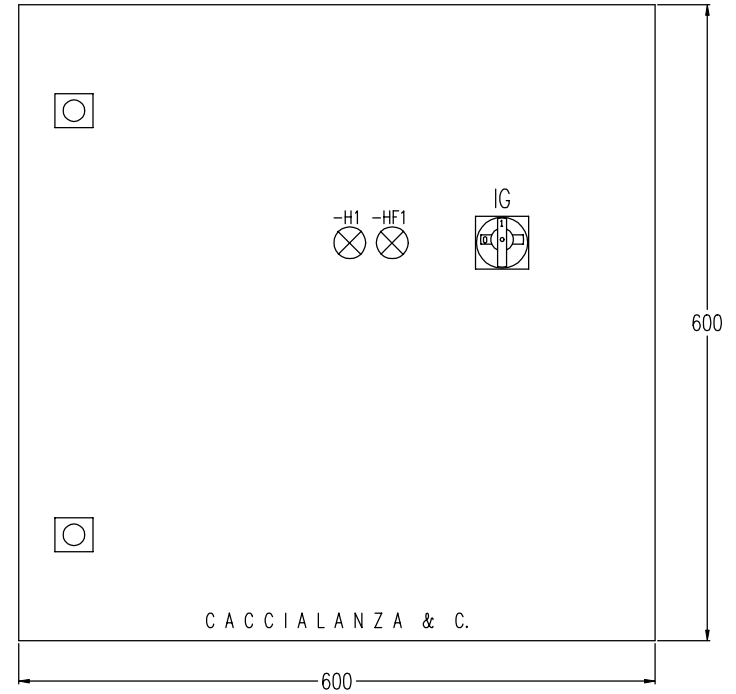


DEPTH: 210mm

SPAR1

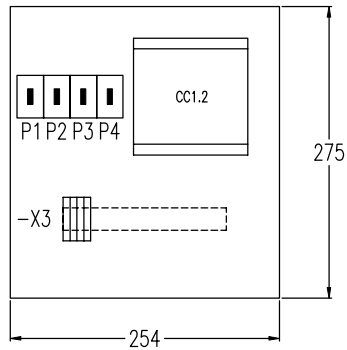

SPAR1

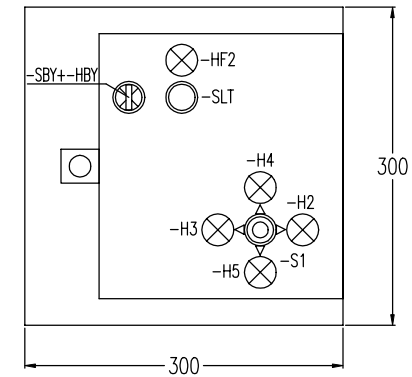

DEPTH: 210mm

DATE	14.09.2001
SCALE	/
DRAWN	An.T.
0 ISSUED	14.09.01 CHECKED AL.T.
REV.	MODIFY DATE APPROVED A.M.