


DETAIL "A"

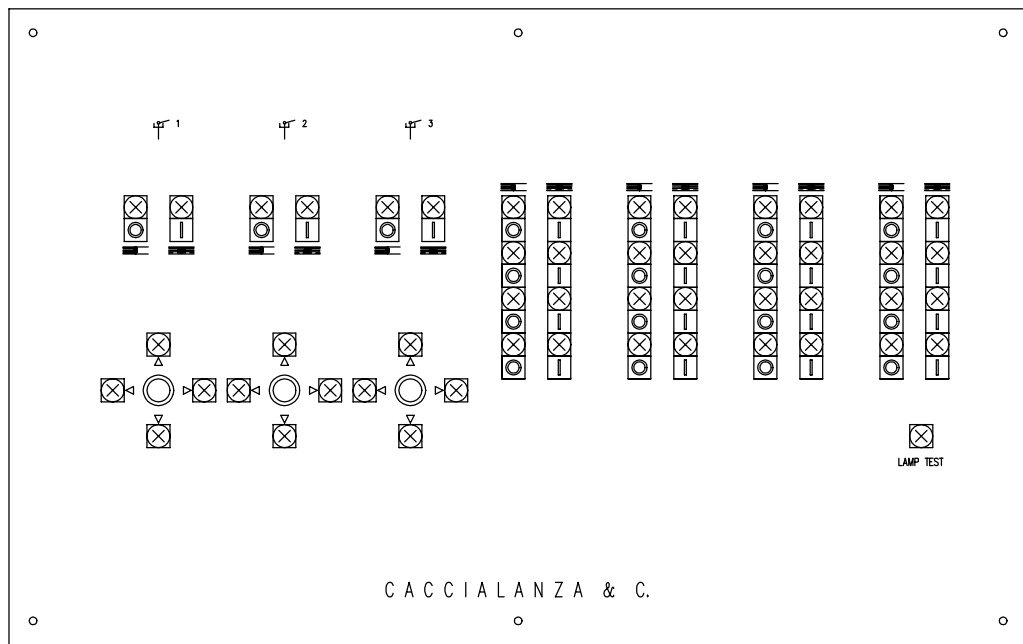

DEGREE OF PROTECTION IP55
(EN60529/10.91)
COLOR RAL 3000

Rev.	Date	Description	Drawn	Checked	Approved
0	27.01.99	ISSUED	CA	CA	

CACCIALANZA & C. s.p.a. ANTINCENDIO SICUREZZA ANTINQUINAMENTO SEGRATE (MILANO) - ITALY			Client / Project			
Drawn 27.01.99 CA Checked 27.01.99 CA Approved Code			Title TYPICAL POWER AND CONTROL PANEL FOR 3 MONITORS GENERAL VIEW			
Date 27.01.99		Name CA		Size A 3		
Date 27.01.99		Name CA		Scale 1:100		
Date 27.01.99		Name CA		Dwg nr. 46700132		
Date 27.01.99		Name CA		Rev. 0		
Date 27.01.99		Name CA		Sheet 1 of 1		

THIS DRAWING IS THE PROPERTY OF CACCIALANZA & C. S.p.A. AND IS NOT TO BE REPRODUCED OR USED TO FURNISH ANY INFORMATION FOR MAKING OF DRAWINGS OR APPARATUS EXCEPT WHERE PROVIDED FOR BY AGREEMENT WITH SAID COMPANY